


ROOF PLAN
Scale 1:100

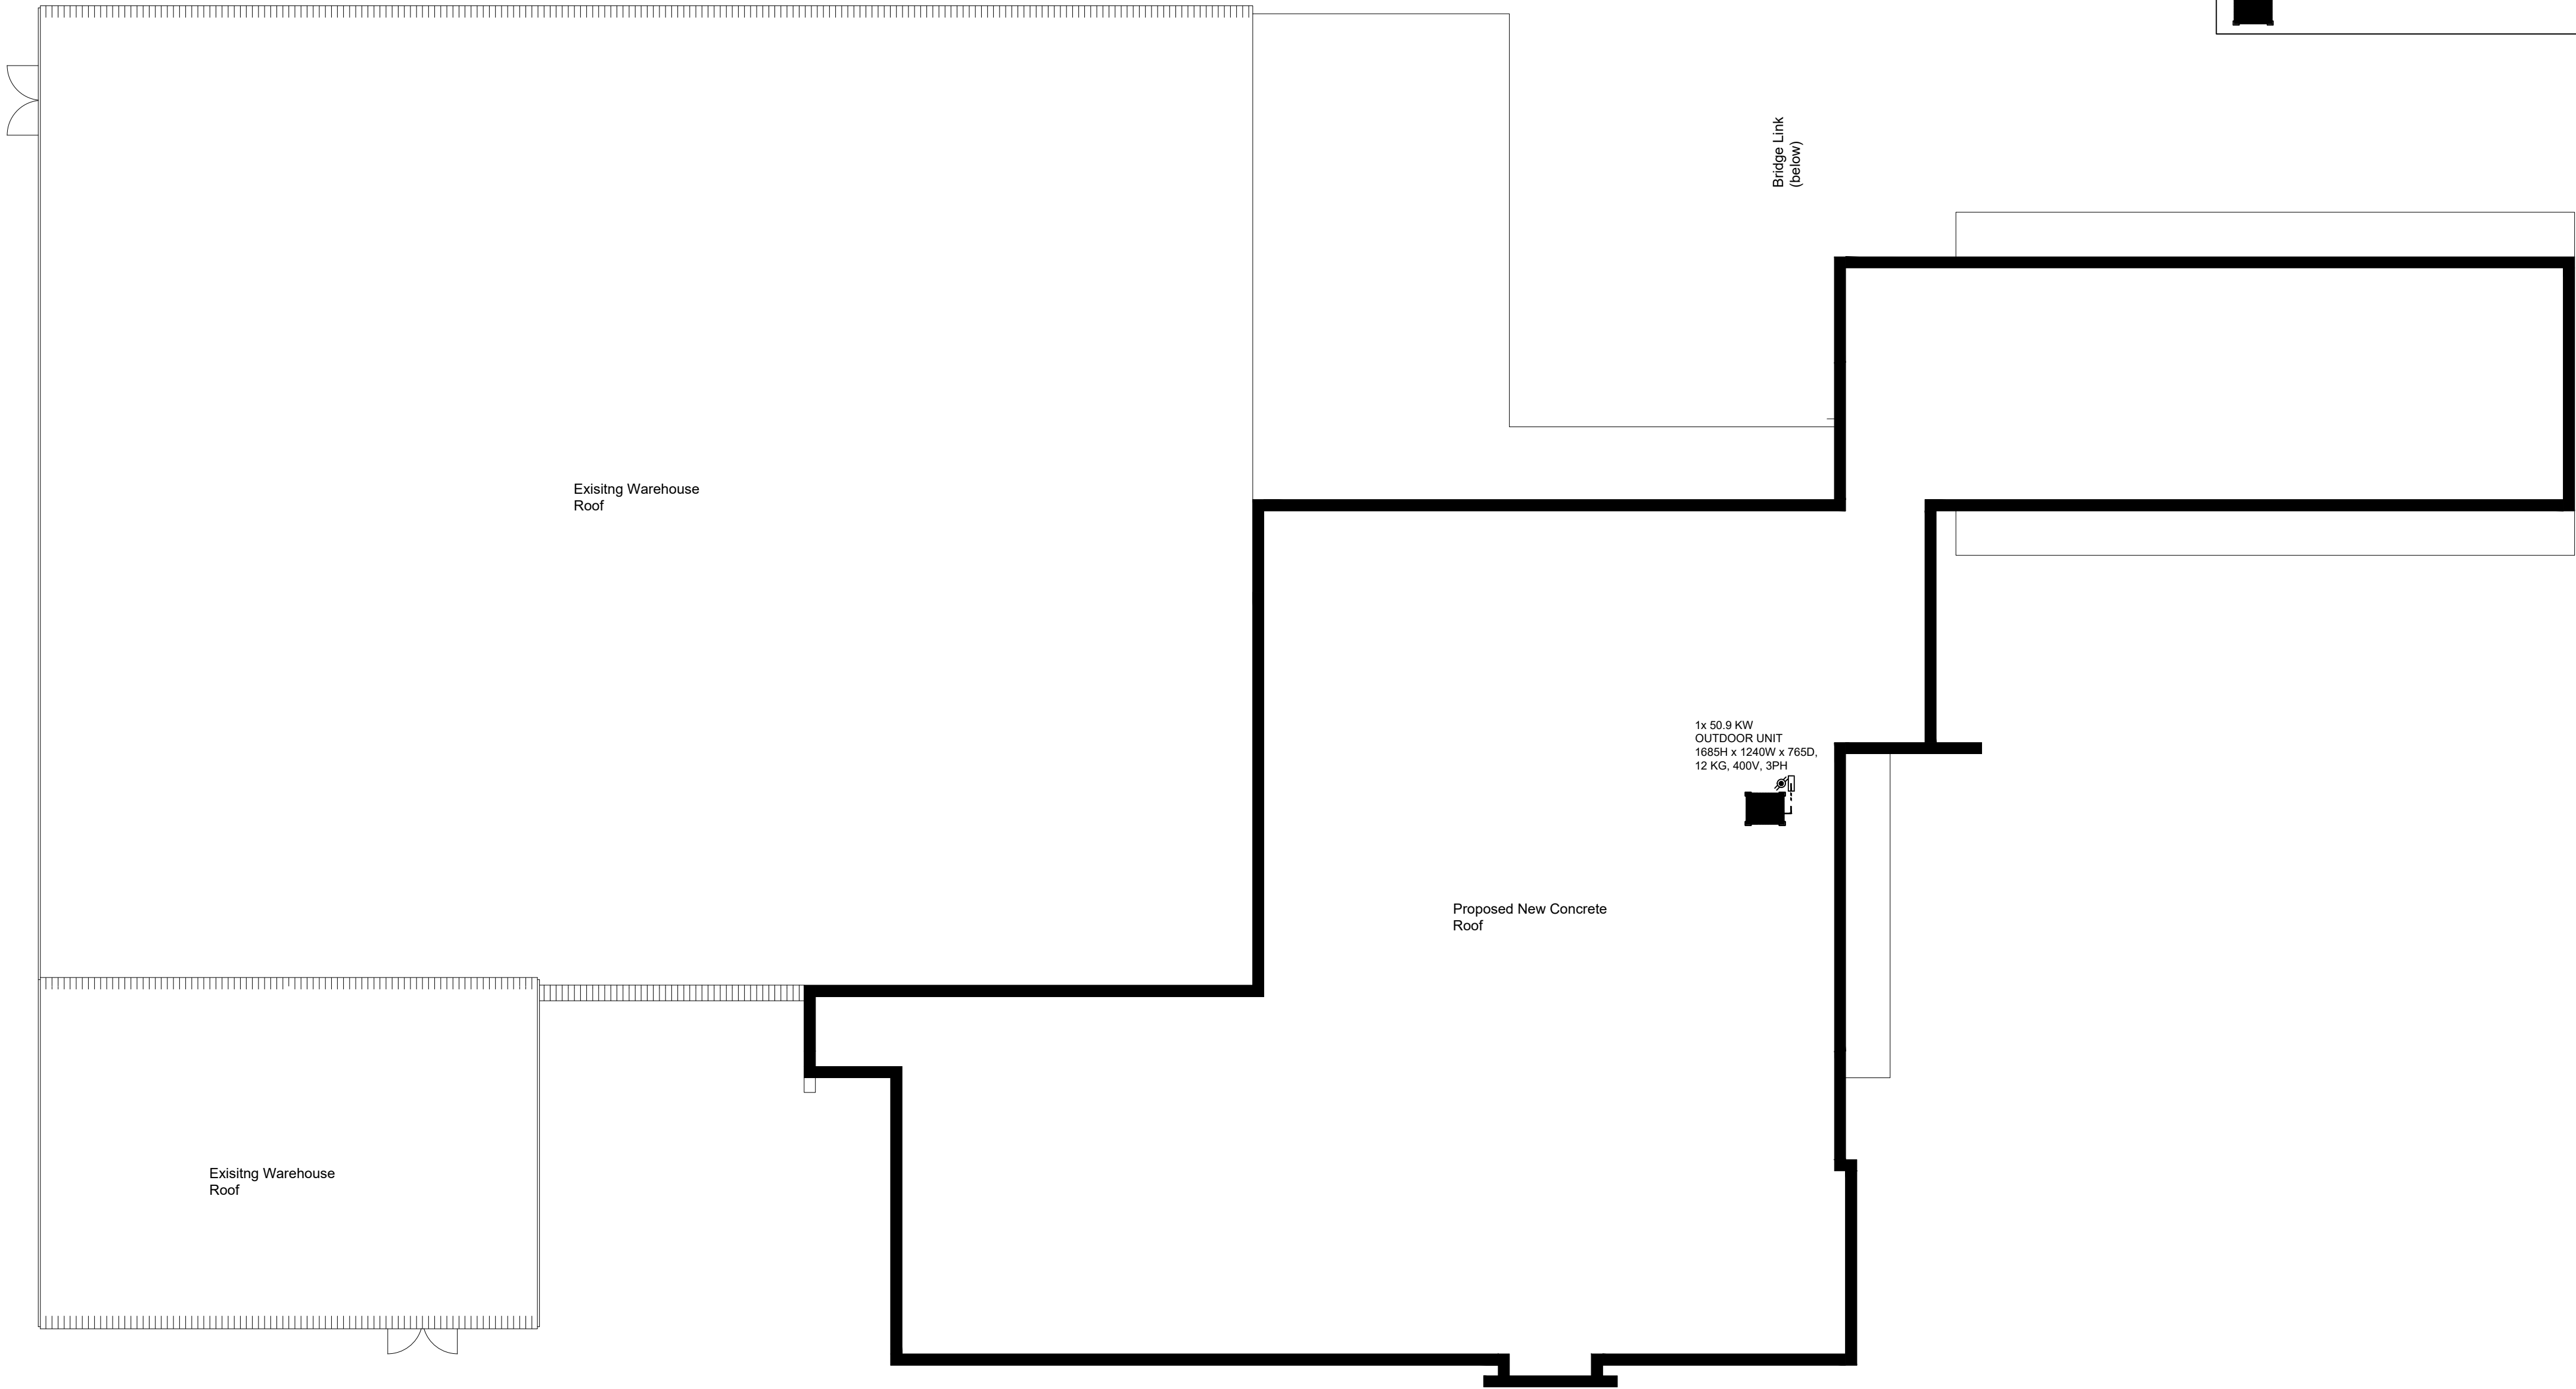

LEGEND:	
	- EXTRACT AIR DUCTING
	- SINGLE PHASE ISOLATOR
	- THREE PHASE ISOLATOR
	- AC CONTROLLER WITH DRAWBOX
	- PRIMARY REFRIGERANT PIPING
	- MAIN CONDENSATE LINE
	- UNDER CEILING UNIT
	- BS BOX
	- OUTDOOR UNIT

- GENERAL NOTES**
- FIGURED DIMENSIONS ONLY TO BE USED.
 - COORDINATES BASED ON WGS84
 - LEVELS BASED ON MSL DATUM
 - DISCREPANCIES, ERRORS AND OMISSIONS ARE TO BE REPORTED TO ENGINEER IMMEDIATELY THEY BECOME EVIDENT.
 - SHOP DRAWINGS TO BE SUBMITTED FOR APPROVAL PRIOR TO MANUFACTURE OR INSTALLATION.
 - COPYRIGHT AND RIGHT OF REPRODUCTION OF THIS DRAWINGS OR ANY PORTION THEREOF IS RESERVED.

Rev	Date	Issued for	Approved
		Preliminary	
		Information	
0	21/11/17	Tender Contract	
		Measurement	
		Construction	
		Approval	

Client:

THE INNOVATIONHUB

GAUTENG GROWTH AND DEVELOPMENT AGENCY

Phunga Consulting Engineers

Route 21 Corporate Park, Block D, 19 Sovereign Drive Irene, Centurion, 0157 South Africa.
Tel: (+27)12 345 6694, Fax: (+27)12 345 6813,
E-mail: info@phunga.co.za,
Web: www.phunga.co.za

Project Title:
New Biotechnology Industrial Park Phase 1 C Extension

Drawing Title: PHG-RF-202-HV 01 Rev. 0	Designed by: L.G; Eng
Date November 2017	Drawn by: L.G; Eng
Scale As shown	Checked by: L.G; Eng

Scale on reduced Drawing

101mm on Original Drawing

North Arrow