


INDOOR VRV UNIT				
Code	Area	Type	Kw	Quantity
AC SF.01	Lab 1	Ceiling Suspended Unit	5,7	1
AC SF.02	Lab 1	Ceiling Suspended Unit	5,7	1
AC SF.03	Lab 2	Ceiling Suspended Unit	4,4	1
AC SF.04	Lab 2	Ceiling Suspended Unit	4,4	1
AC SF.05	Lab 3	Ceiling Suspended Unit	4,45	1
AC SF.06	Lab 3	Ceiling Suspended Unit	4,45	1
AC SF.07	Lab 4	Ceiling Suspended Unit	3,2	1
AC SF.08	Lab 4	Ceiling Suspended Unit	3,2	1
AC SF.09	Lab 4	Ceiling Suspended Unit	3,2	1

LEGEND:	
	- EXTRACT AIR DUCTING
	- SINGLE PHASE ISOLATOR
	- THREE PHASE ISOLATOR
	- AC CONTROLLER WITH DRAWBOX
	- PRIMARY REFRIGERANT PIPING
	- MAIN CONDENSATE LINE
	- UNDER CEILING UNIT
	- BS BOX
	- OUTDOOR UNIT

- GENERAL NOTES**
- FIGURED DIMENSIONS ONLY TO BE USED.
 - COORDINATES BASED ON WGS84
 - LEVELS BASED ON MSL DATUM
 - DISCREPANCIES, ERRORS AND OMISSIONS ARE TO BE REPORTED TO ENGINEER IMMEDIATELY THEY BECOME EVIDENT.
 - SHOP DRAWINGS TO BE SUBMITTED FOR APPROVAL PRIOR TO MANUFACTURE OR INSTALLATION.
 - COPYRIGHT AND RIGHT OF REPRODUCTION OF THIS DRAWINGS OR ANY PORTION THEREOF IS RESERVED.

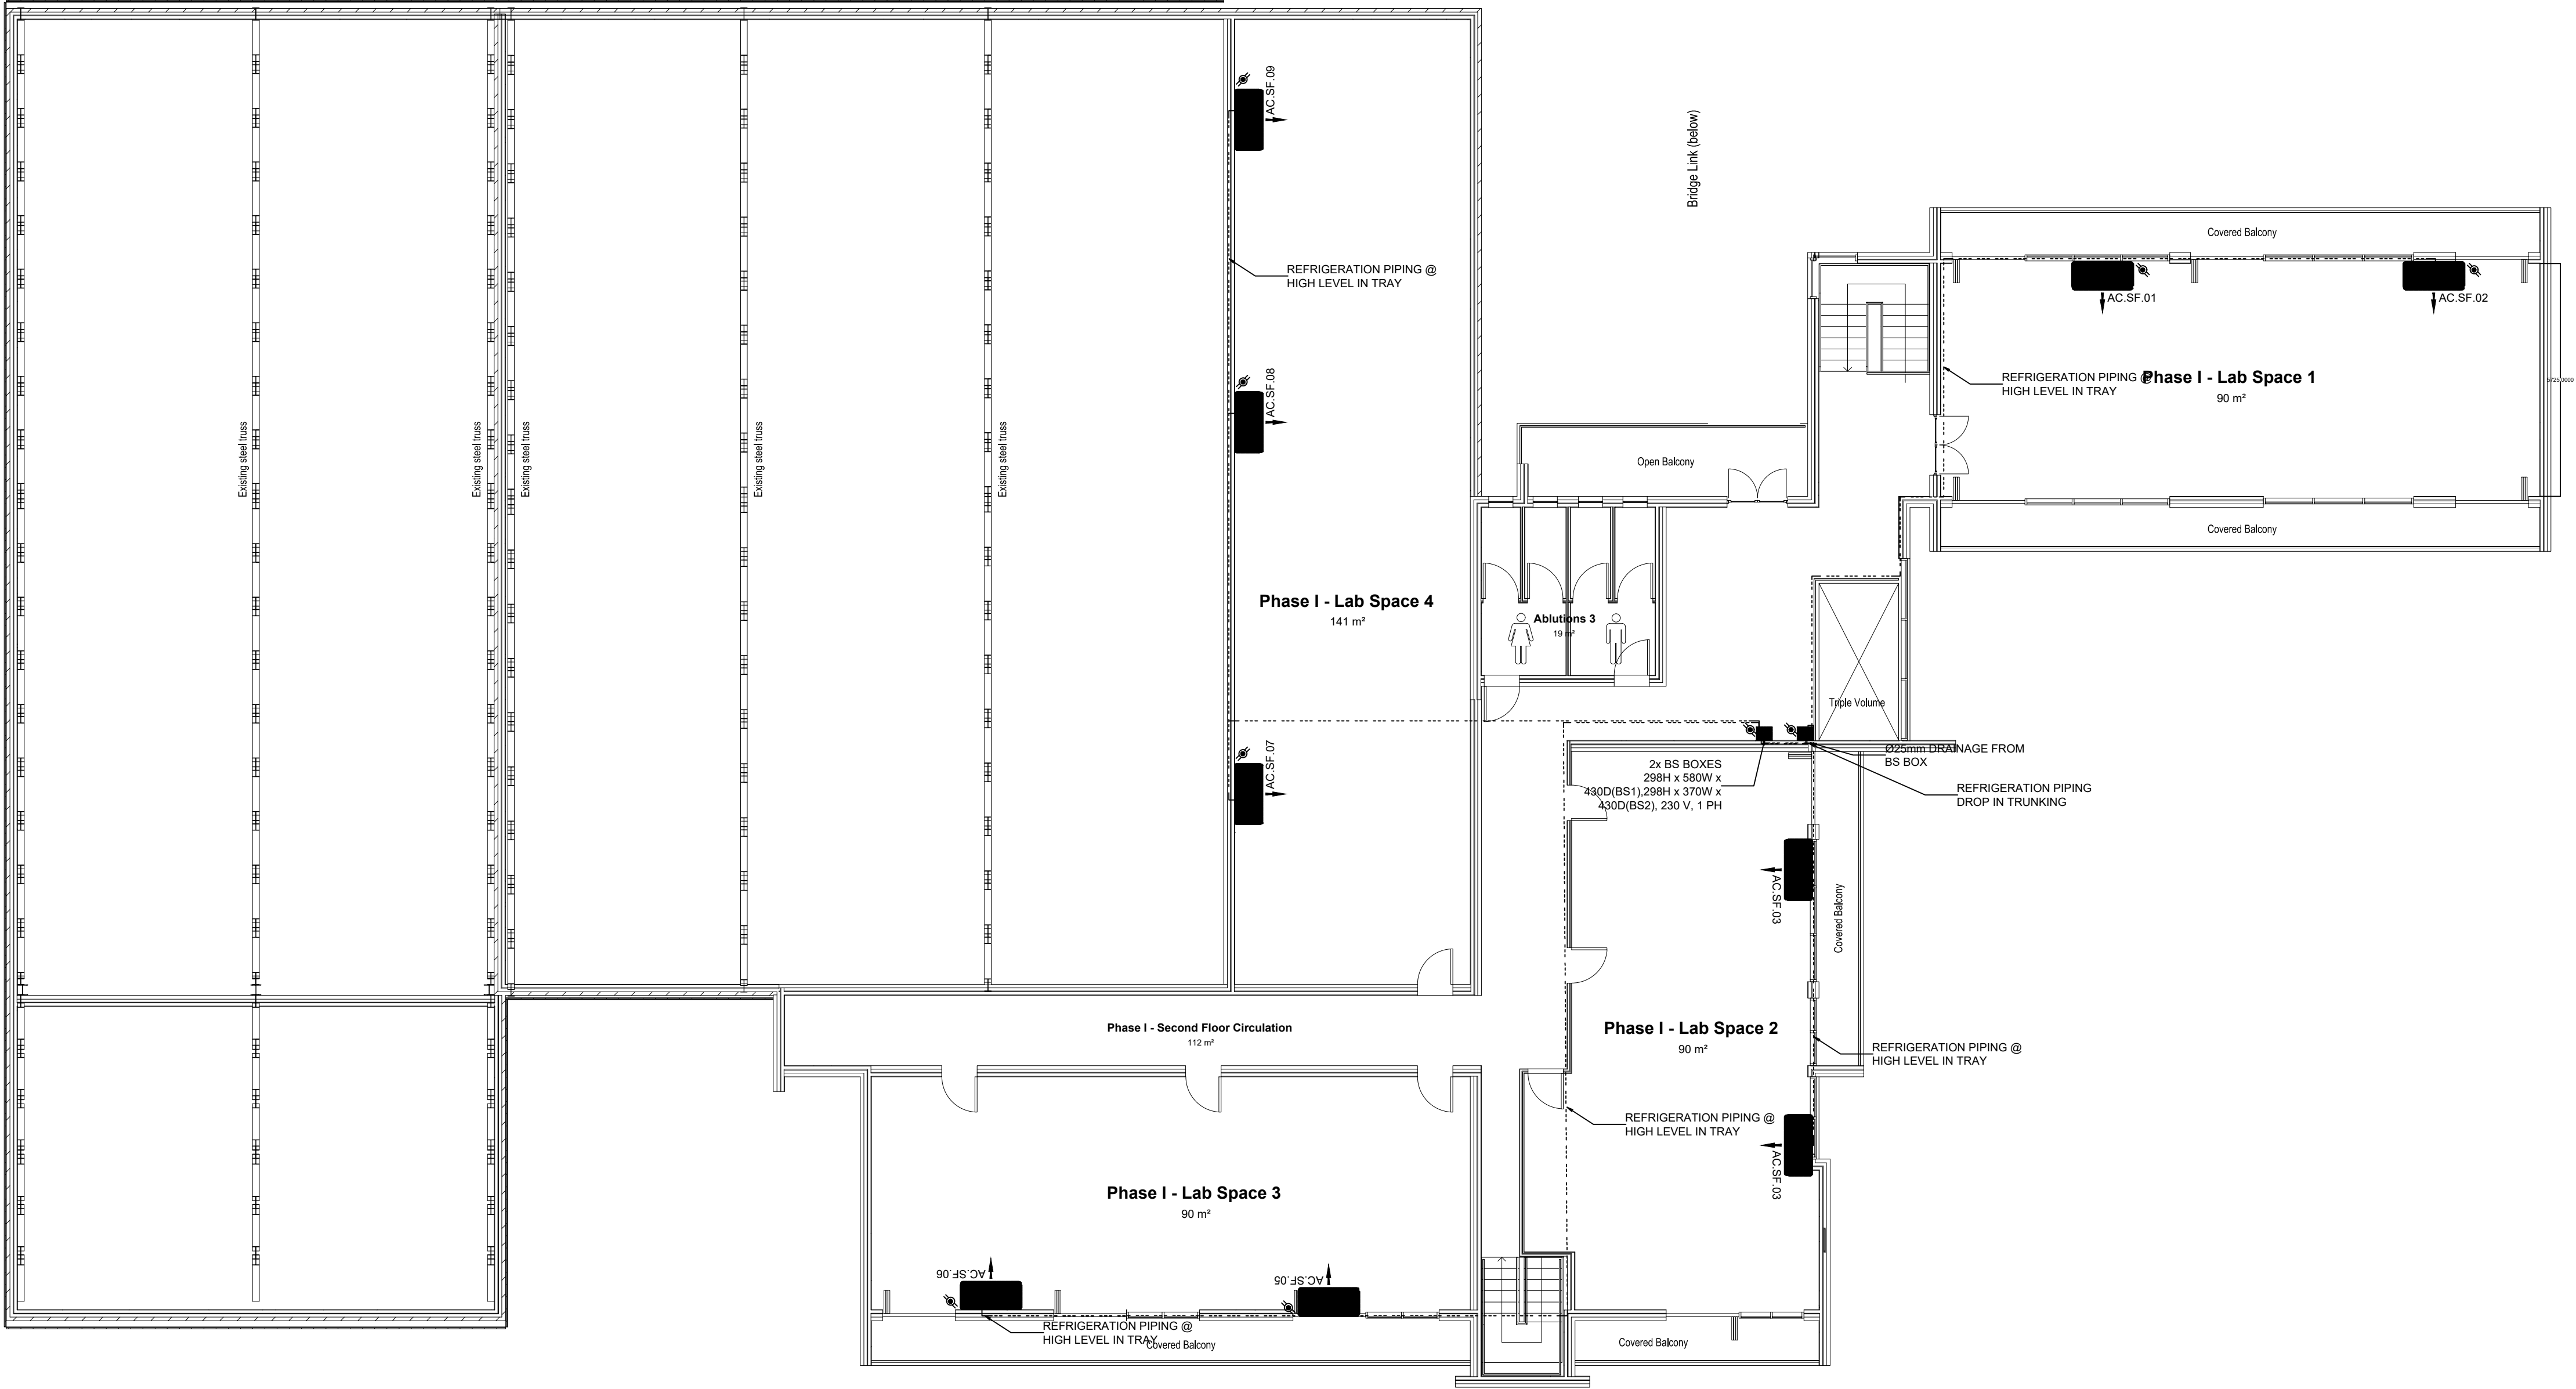

SECOND FLOOR PLAN
Scale 1:100

Rev	Date	Issued for	Approved
		Preliminary	
		Information	
0	21/11/17	Tender Contract	
		Measurement	
		Construction	
		Approval	

Client:

THE INNOVATION HUB

GAUTENG GROWTH AND DEVELOPMENT AGENCY

Phunga Consulting Engineers
Quality Green Solutions

Route 21 Corporate Park, Block D, 19 Sovereign Drive Irene,
Centurion, 0157 South Africa,
Tel: (+27)12 345 6694, Fax: (+27)12 345 6813,
E-mail: info@phunga.co.za,
Web: www.phunga.co.za

Project Title: Biotechnology Industrial Park Phase 1 C Extension	
Drawing Title: PHG-SF-201-HV 01 Rev_0	Designed by: L.G; Eng
Date: November 2017	Drawn by: L.G; Eng
Scale: As shown	Checked by: L.G; Eng