


SECOND FLOOR PLAN
Scale 1:100

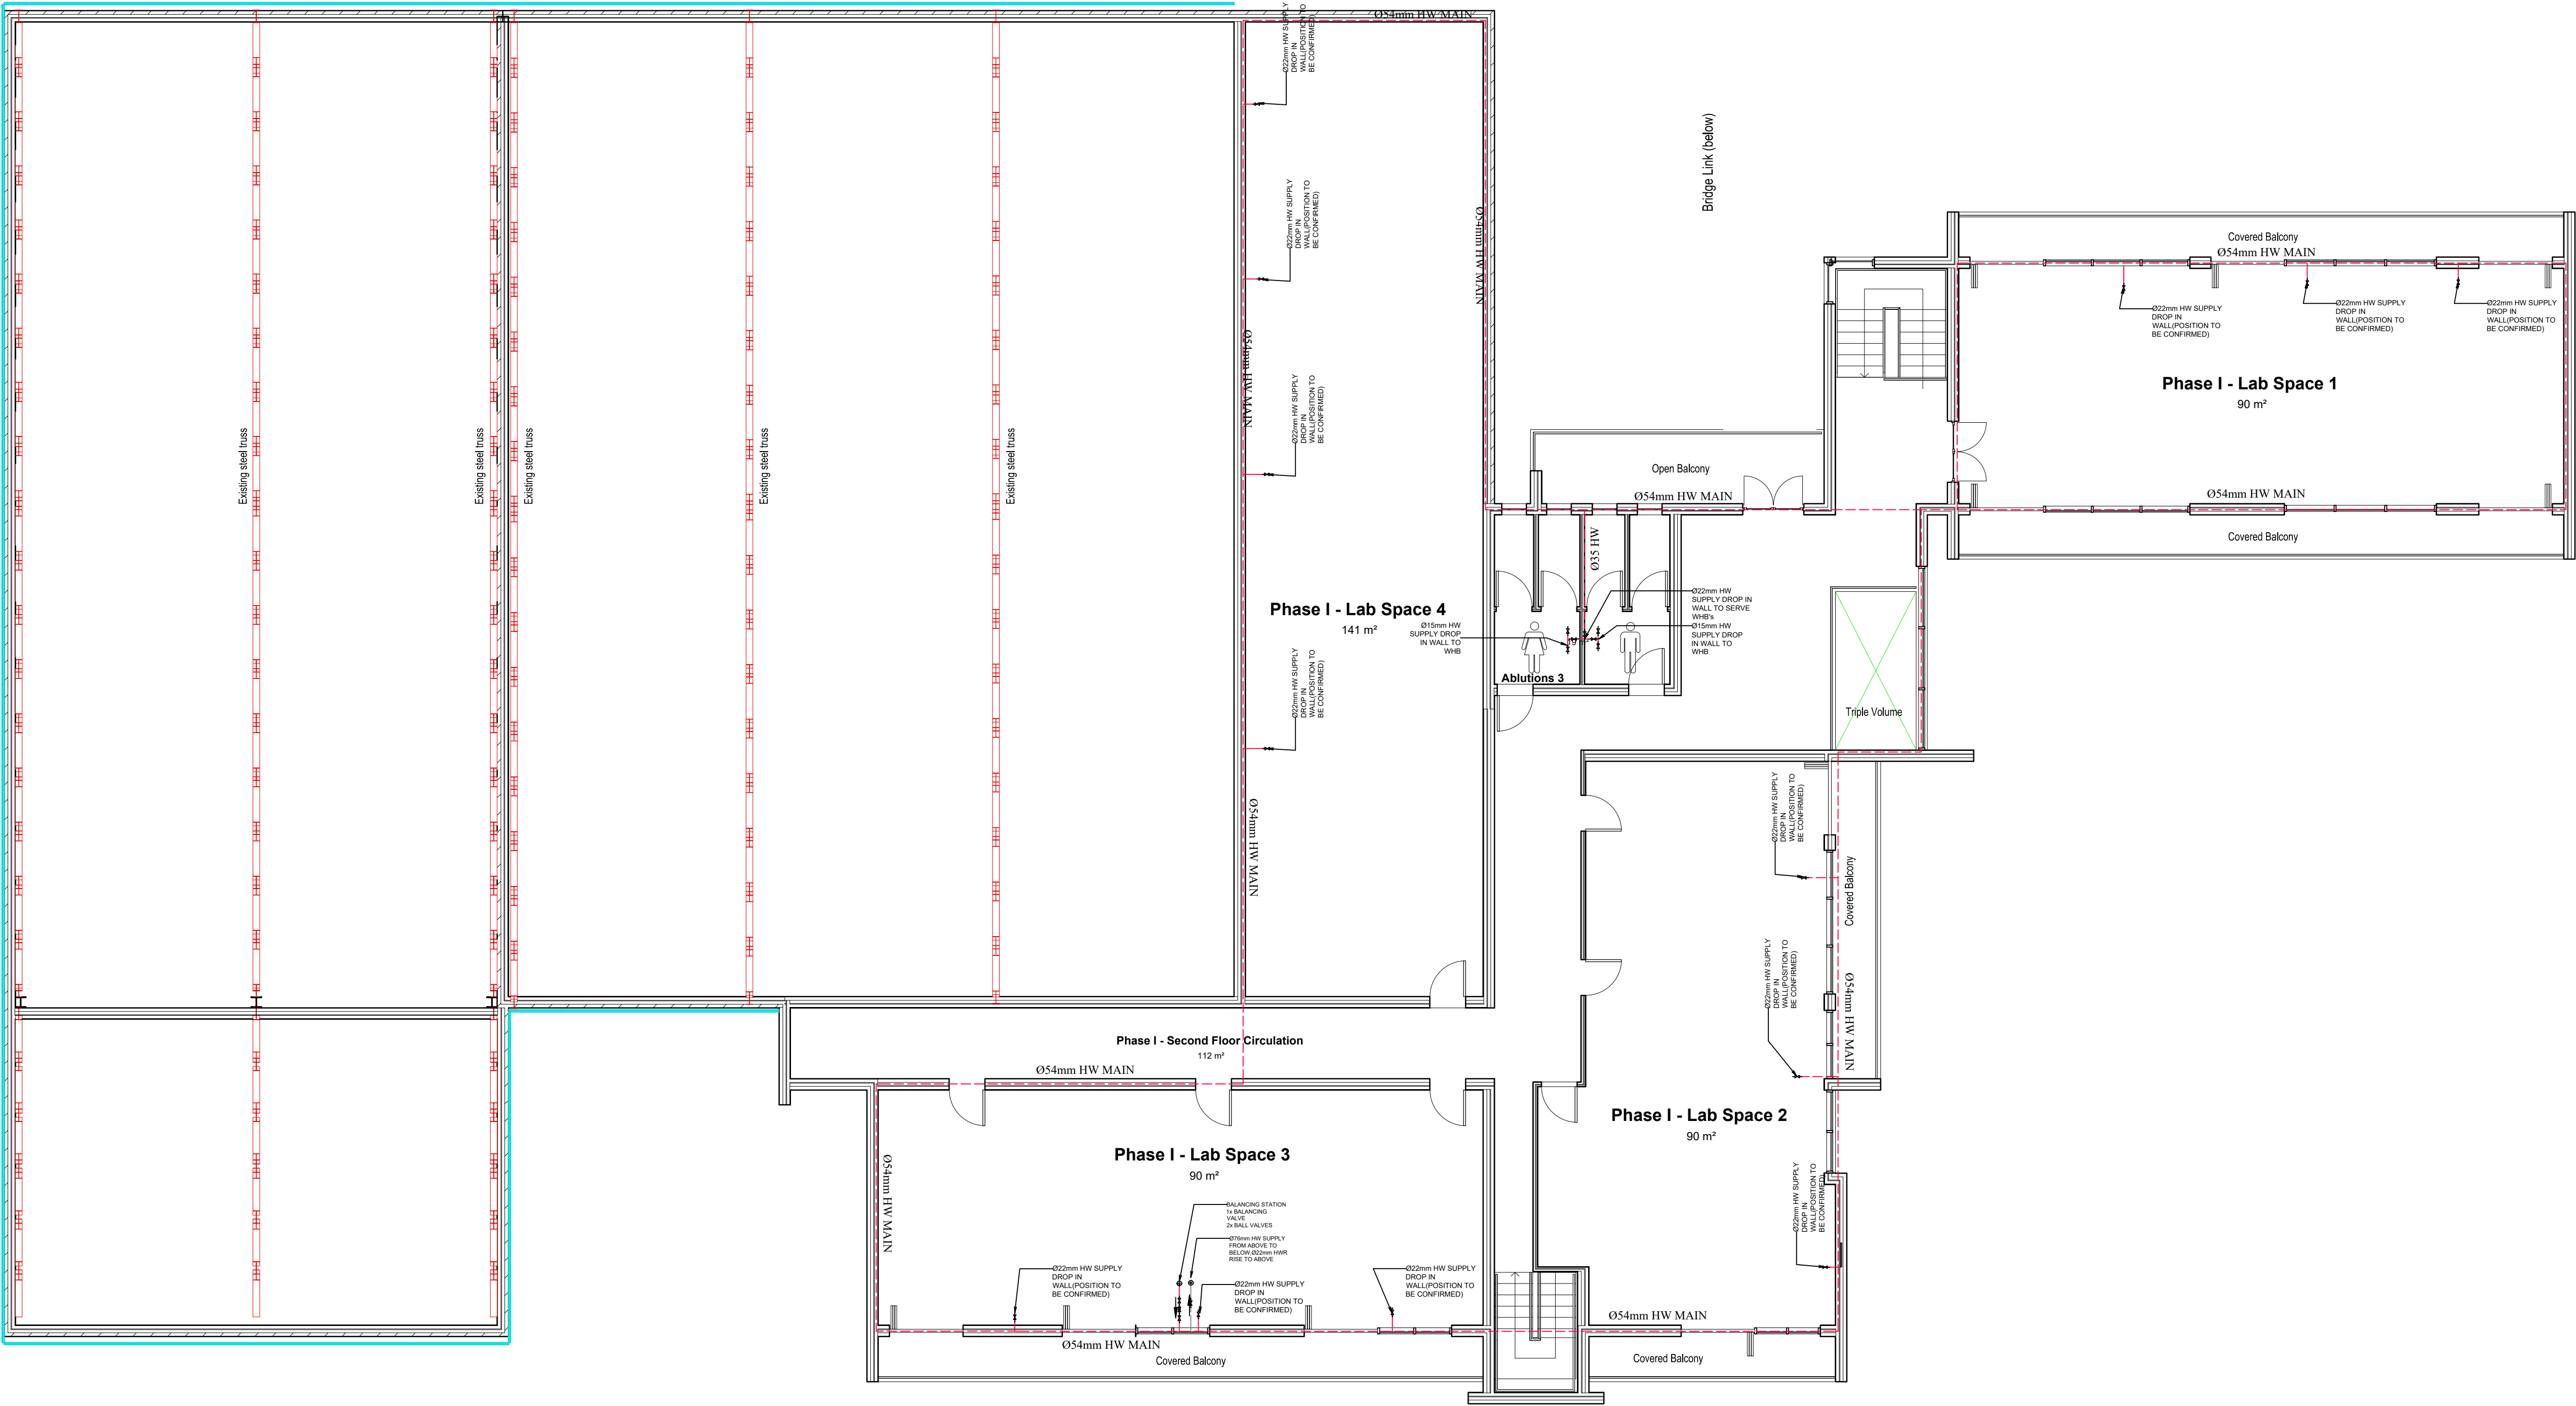

PLUMBING LEGEND		
Symbol	QTY	Description
	·	SHUT OFF VALVE.
	·	BALANCING VALVE.
	·	RISER.
	·	HOT WATER SUPPLY PIPING.
	·	HOT WATER RETURN PIPING.
	·	COLD WATER SUPPLY PIPING.
	·	WATER SUPPLY POINT.

GENERAL NOTES

- FIGURED DIMENSIONS ONLY TO BE USED.
- COORDINATES BASED ON WGS84
- LEVELS BASED ON MSL DATUM
- DISCREPANCIES, ERRORS AND OMISSIONS ARE TO BE REPORTED TO ENGINEER IMMEDIATELY THEY BECOME EVIDENT.
- SHOP DRAWINGS TO BE SUBMITTED FOR APPROVAL PRIOR TO MANUFACTURE OR INSTALLATION.
- COPYRIGHT AND RIGHT OF REPRODUCTION OF THIS DRAWINGS OR ANY PORTION THEREOF IS RESERVED.

Rev	Date	Issued for	Approved
		Preliminary	
		Information	
0	21/11/17	Tender Contract	
		Measurement	
		Construction	
		Approval	

Client:

THE INNOVATION HUB

GAUTENG GROWTH AND DEVELOPMENT AGENCY

Phunga Consulting Engineers
Quality Green Solutions

Route 21 Corporate Park, Block D, 19 Sovereign Drive Irene,
Centurion, 0157 South Africa,
Tel: (+27)12 345 6694, Fax: (+27)12 345 6813,
E-mail: info@phunga.co.za,
Web: www.phunga.co.za

Project Title:
New Biotechnology Industrial Park Phase 1 C Extension

Drawing Title: PHG-SF-200-WS01 Rev_0	Designed by: L.G; Eng
Date: November 2017	Drawn by: L.G; Eng
Scale: As shown	Checked by: L.G; Eng

