



PLUMBING LEGEND		
Symbol	QTY	Description
	·	SHUT OFF VALVE.
	·	BALANCING VALVE.
	·	RISER.
	·	HOT WATER SUPPLY PIPING.
	·	HOT WATER RETURN PIPING.
	·	COLD WATER SUPPLY PIPING.
	·	WATER SUPPLY POINT.

- GENERAL NOTES**
- FIGURED DIMENSIONS ONLY TO BE USED.
 - COORDINATES BASED ON WGS84
 - LEVELS BASED ON MSL DATUM
 - DISCREPANCIES, ERRORS AND OMISSIONS ARE TO BE REPORTED TO ENGINEER IMMEDIATELY THEY BECOME EVIDENT.
 - SHOP DRAWINGS TO BE SUBMITTED FOR APPROVAL PRIOR TO MANUFACTURE OR INSTALLATION.
 - COPYRIGHT AND RIGHT OF REPRODUCTION OF THIS DRAWINGS OR ANY PORTION THEREOF IS RESERVED.

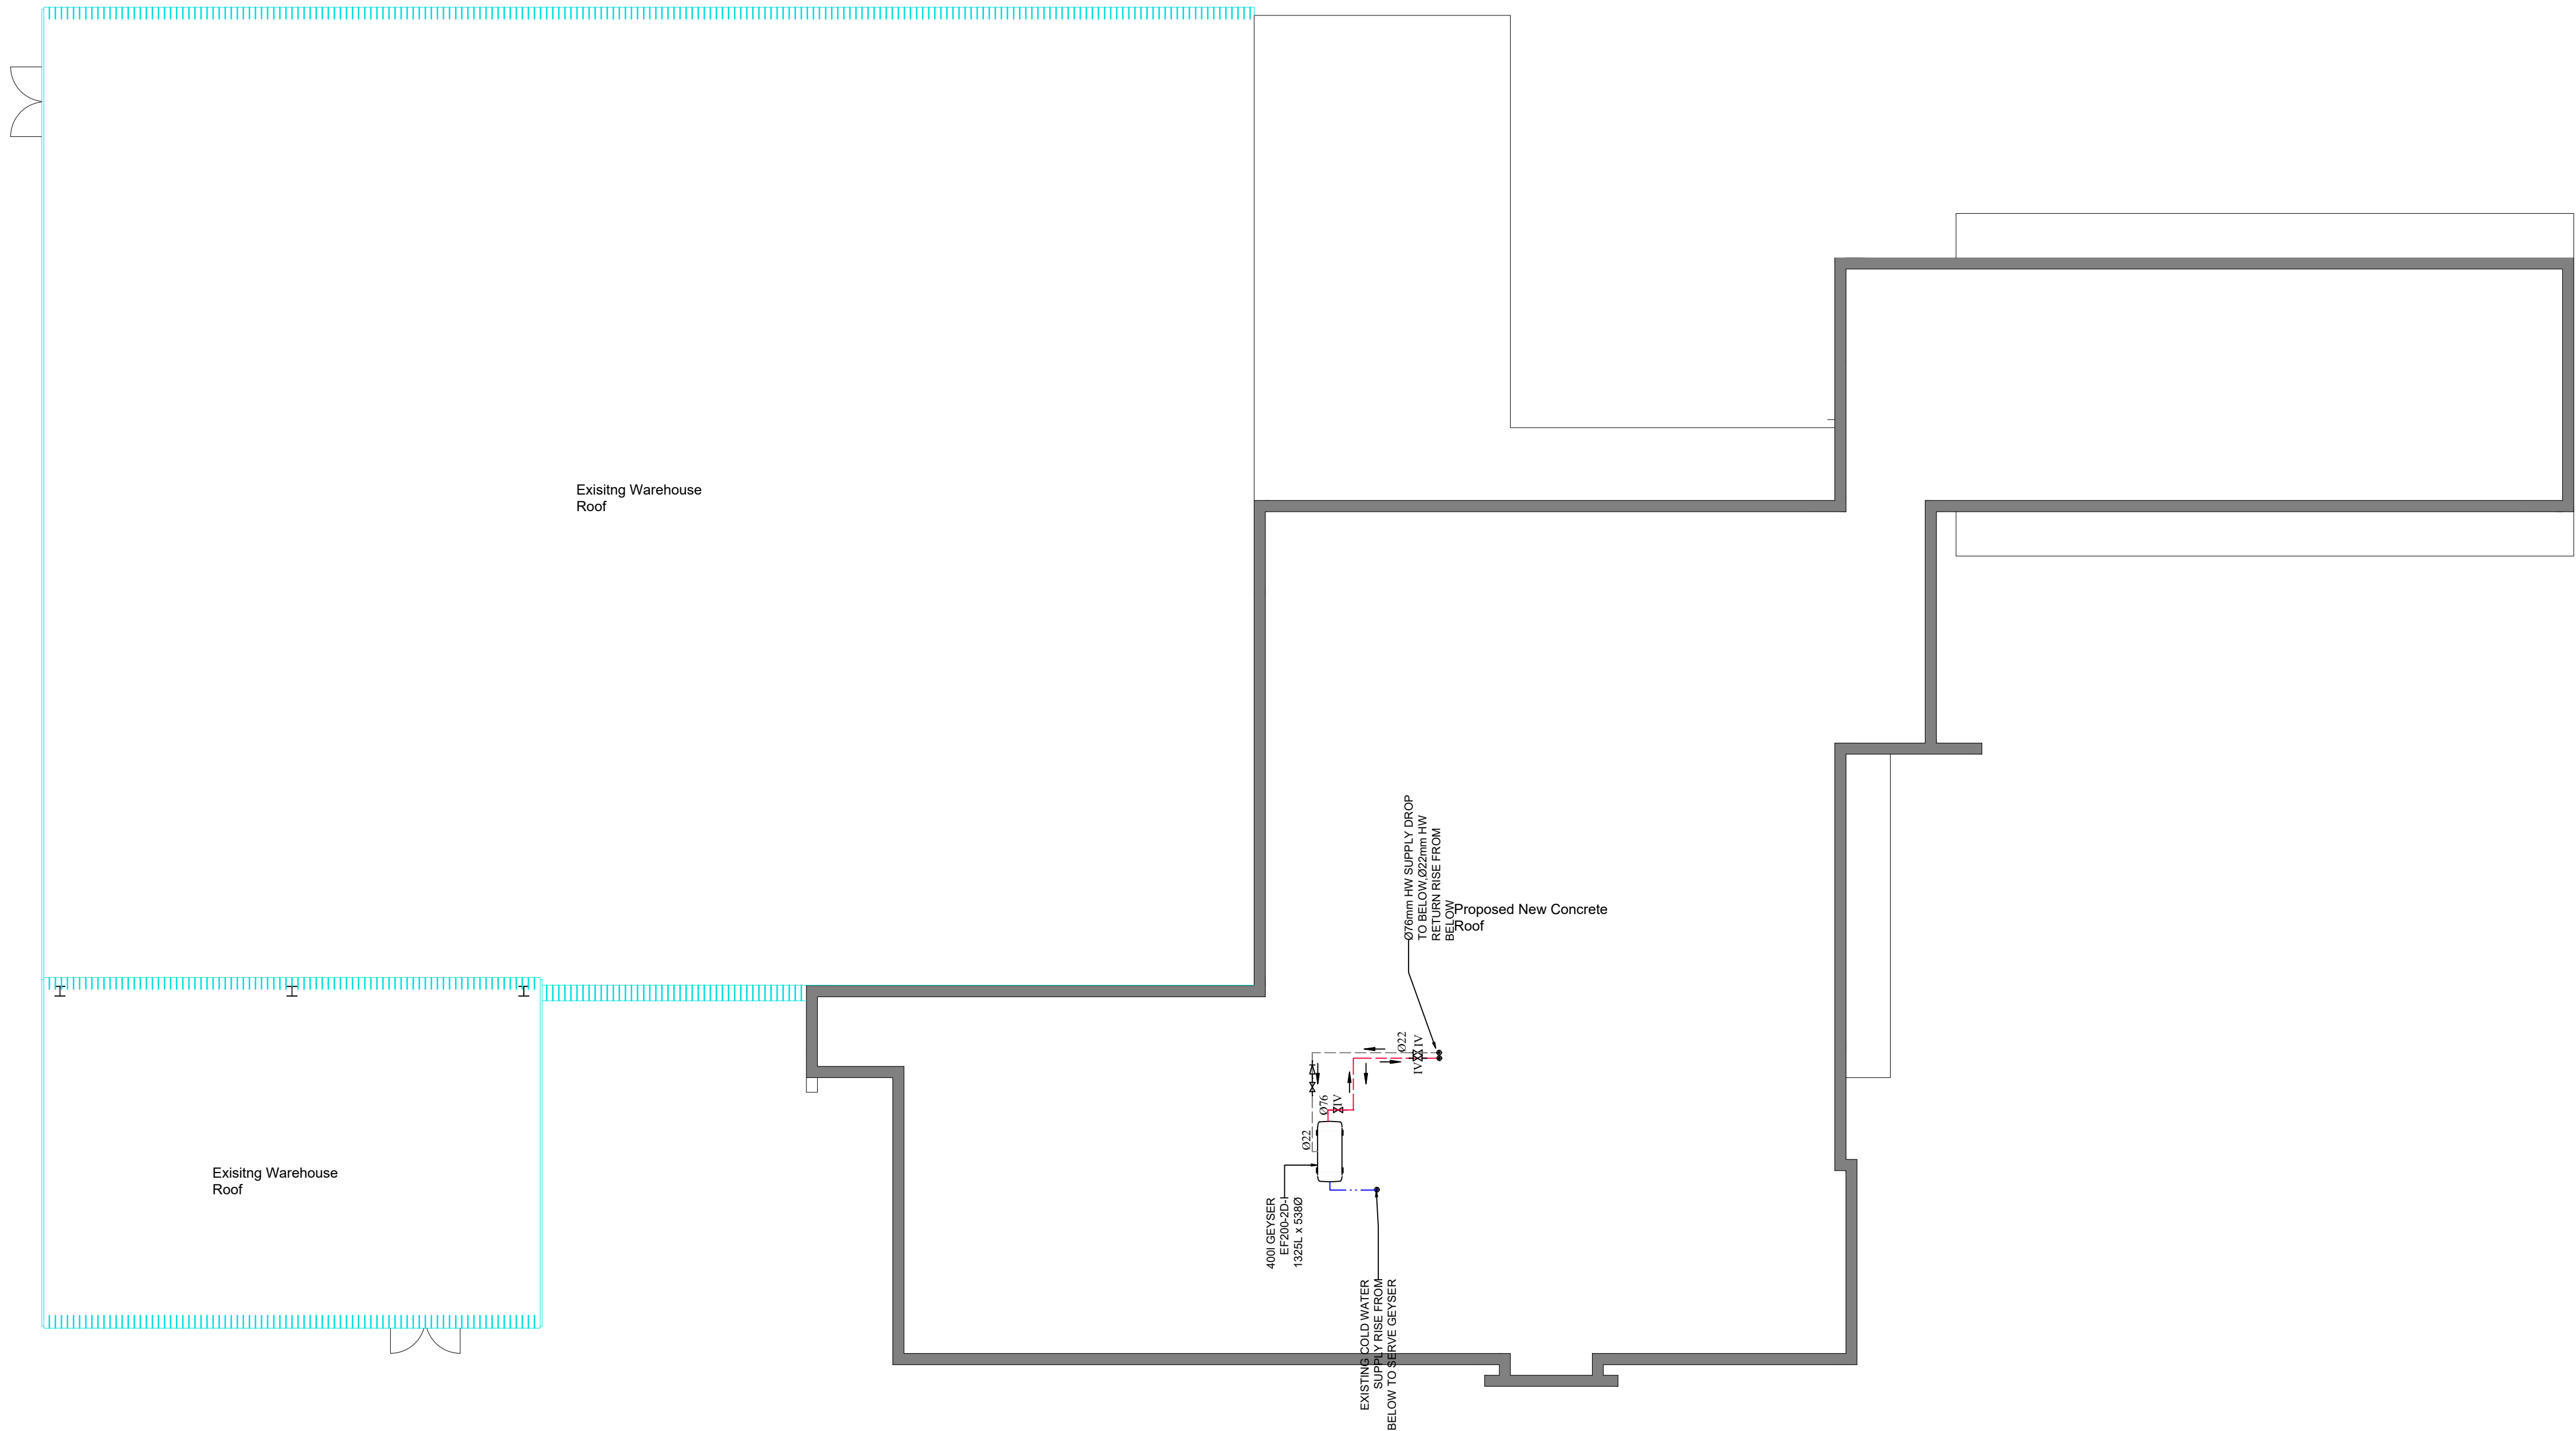

ROOF FLOOR PLAN
Scale 1:100

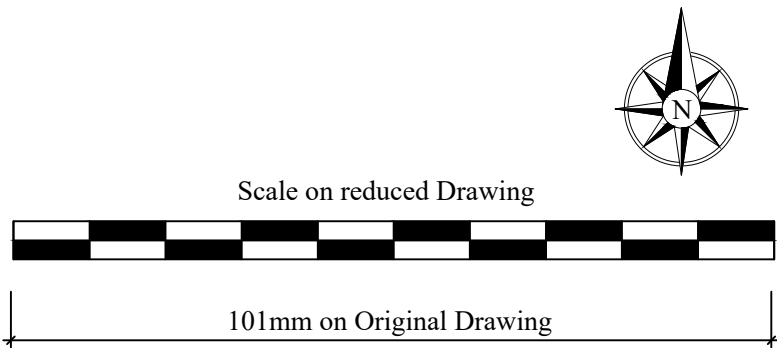

Rev	Date	Issued for	Approved
		Preliminary	
		Information	
0	21/11/17	Tender Contract	
		Measurement	
		Construction	
		Approval	

Client:
THE INNOVATIONHUB®



GAUTENG GROWTH AND DEVELOPMENT AGENCY

Phunga Consulting Engineers
Quality. Growth. Solutions.

Route 21 Corporate Park, Block D, 19 Sovereign Drive Irene,
Centurion, 0157 South Africa,
Tel: (+27)12 345 6694, Fax: (+27)12 345 6813,
E-mail: info@phunga.co.za,
Web: www.phunga.co.za

Project Title:
New Biotechnology Industrial Park Phase 1 C
Extension

Drawing Title: PHG-RF-201-WS01 Rev_0	Designed by: L.G; Eng
Date: November 2017	Drawn by: L.G; Eng
Scale: As shown	Checked by: L.G; Eng