

GENERAL NOTES

- FIGURED DIMENSIONS ONLY TO BE USED.
- COORDINATES BASED ON WGS84
- LEVELS BASED ON MSL DATUM
- DISCREPANCIES, ERRORS AND OMISSIONS ARE TO BE REPORTED TO ENGINEER IMMEDIATELY THEY BECOME EVIDENT.
- SHOP DRAWINGS TO BE SUBMITTED FOR APPROVAL PRIOR TO MANUFACTURE OR INSTALLATION.
- COPYRIGHT AND RIGHT OF REPRODUCTION OF THIS DRAWINGS OR ANY PORTION THEREOF IS RESERVED.

ELECTRICAL LEGEND

C1	REGENT F105Q (BEAM DOUBLE) SILVER
C2	18W LED RECTANGULAR BULKHEAD LIGHT WITH OPAQUE ACRYLIC DIFFUSER EQUAL TO BEKA SERIES 50 OR APPROVED
C9	REGENT BEAM WALL MINI-COLOR CHARCOAL
F1	1x36W VAPOURLINE EQUAL TO BEKA VAPOURLINE OR SIMILAR APPROVED
PC	DAY-NIGHT SWITCH
O	RECESSED 2x4 SINGLE LEVER ONE WAY LIGHT SWITCH
∞	RECESSED 2x4 TWO LEVER ONE WAY LIGHT SWITCH
∞∞	RECESSED 2x4 THREE LEVER ONE WAY LIGHT SWITCH
DB X X	INDICATES CIRCUIT No X / DB No X

Rev	Date	Issued for	Approved
		Preliminary	
		Information	
		Tender Contract	
		Measurement	
01	25/04/2016	Construction	
		Approval	

Client:
THE INNOVATIONHUB




DRIVING GROWTH AND DEVELOPMENT AGENCY

Phunga Consulting Engineers
Quality Driven Solutions

Route 21 Corporate Park, Block D, 63 Regency Drive Irene,
Centurion, 0157 South Africa.
Tel: (+27)12 345 6694, Fax: (+27)12 345 6813,
E-mail: info@phunga.co.za,
Web: www.phunga.co.za

Project Title:
Innovation Hub
Electrical Services

Drawing Title: Ground Floor Lighting Design PHG-GFLD-01	Designed by: G. Mabika
Date: April 2016	Drawn by: G. Mabika
Scale: 1:100	Checked by: MJ Enyeka, Pr No 200930078

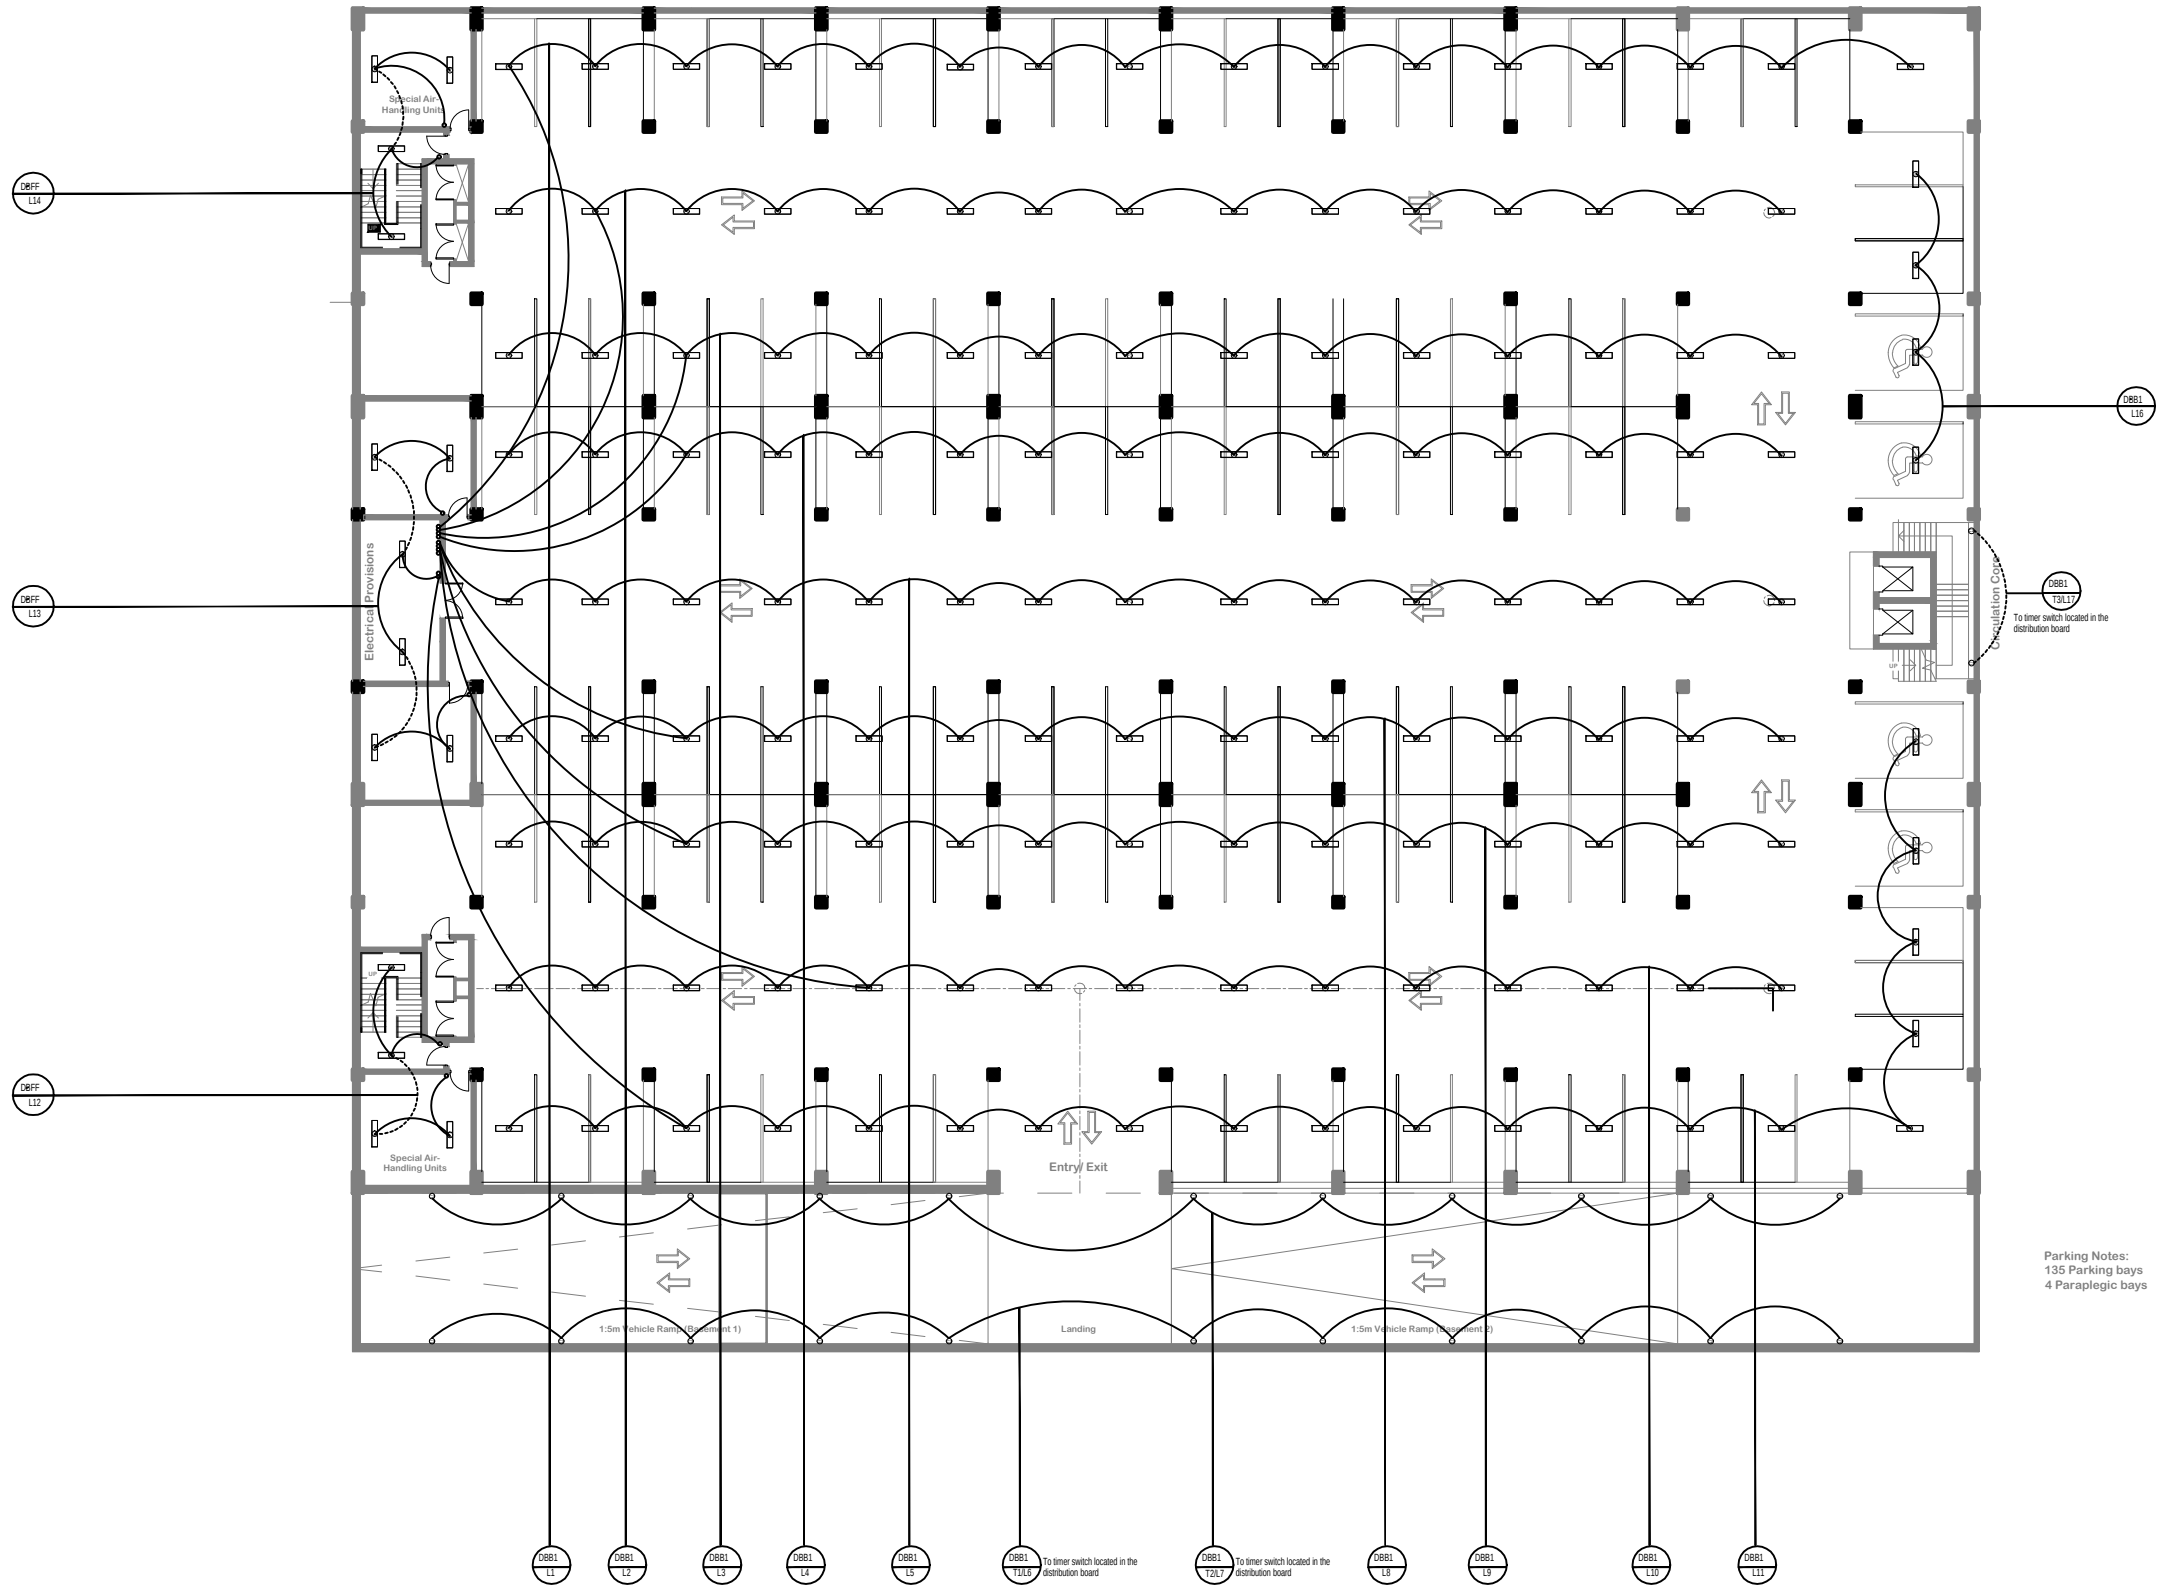

Parking Notes:
135 Parking bays
4 Paraplegic bays

Scale on reduced
Drawing