


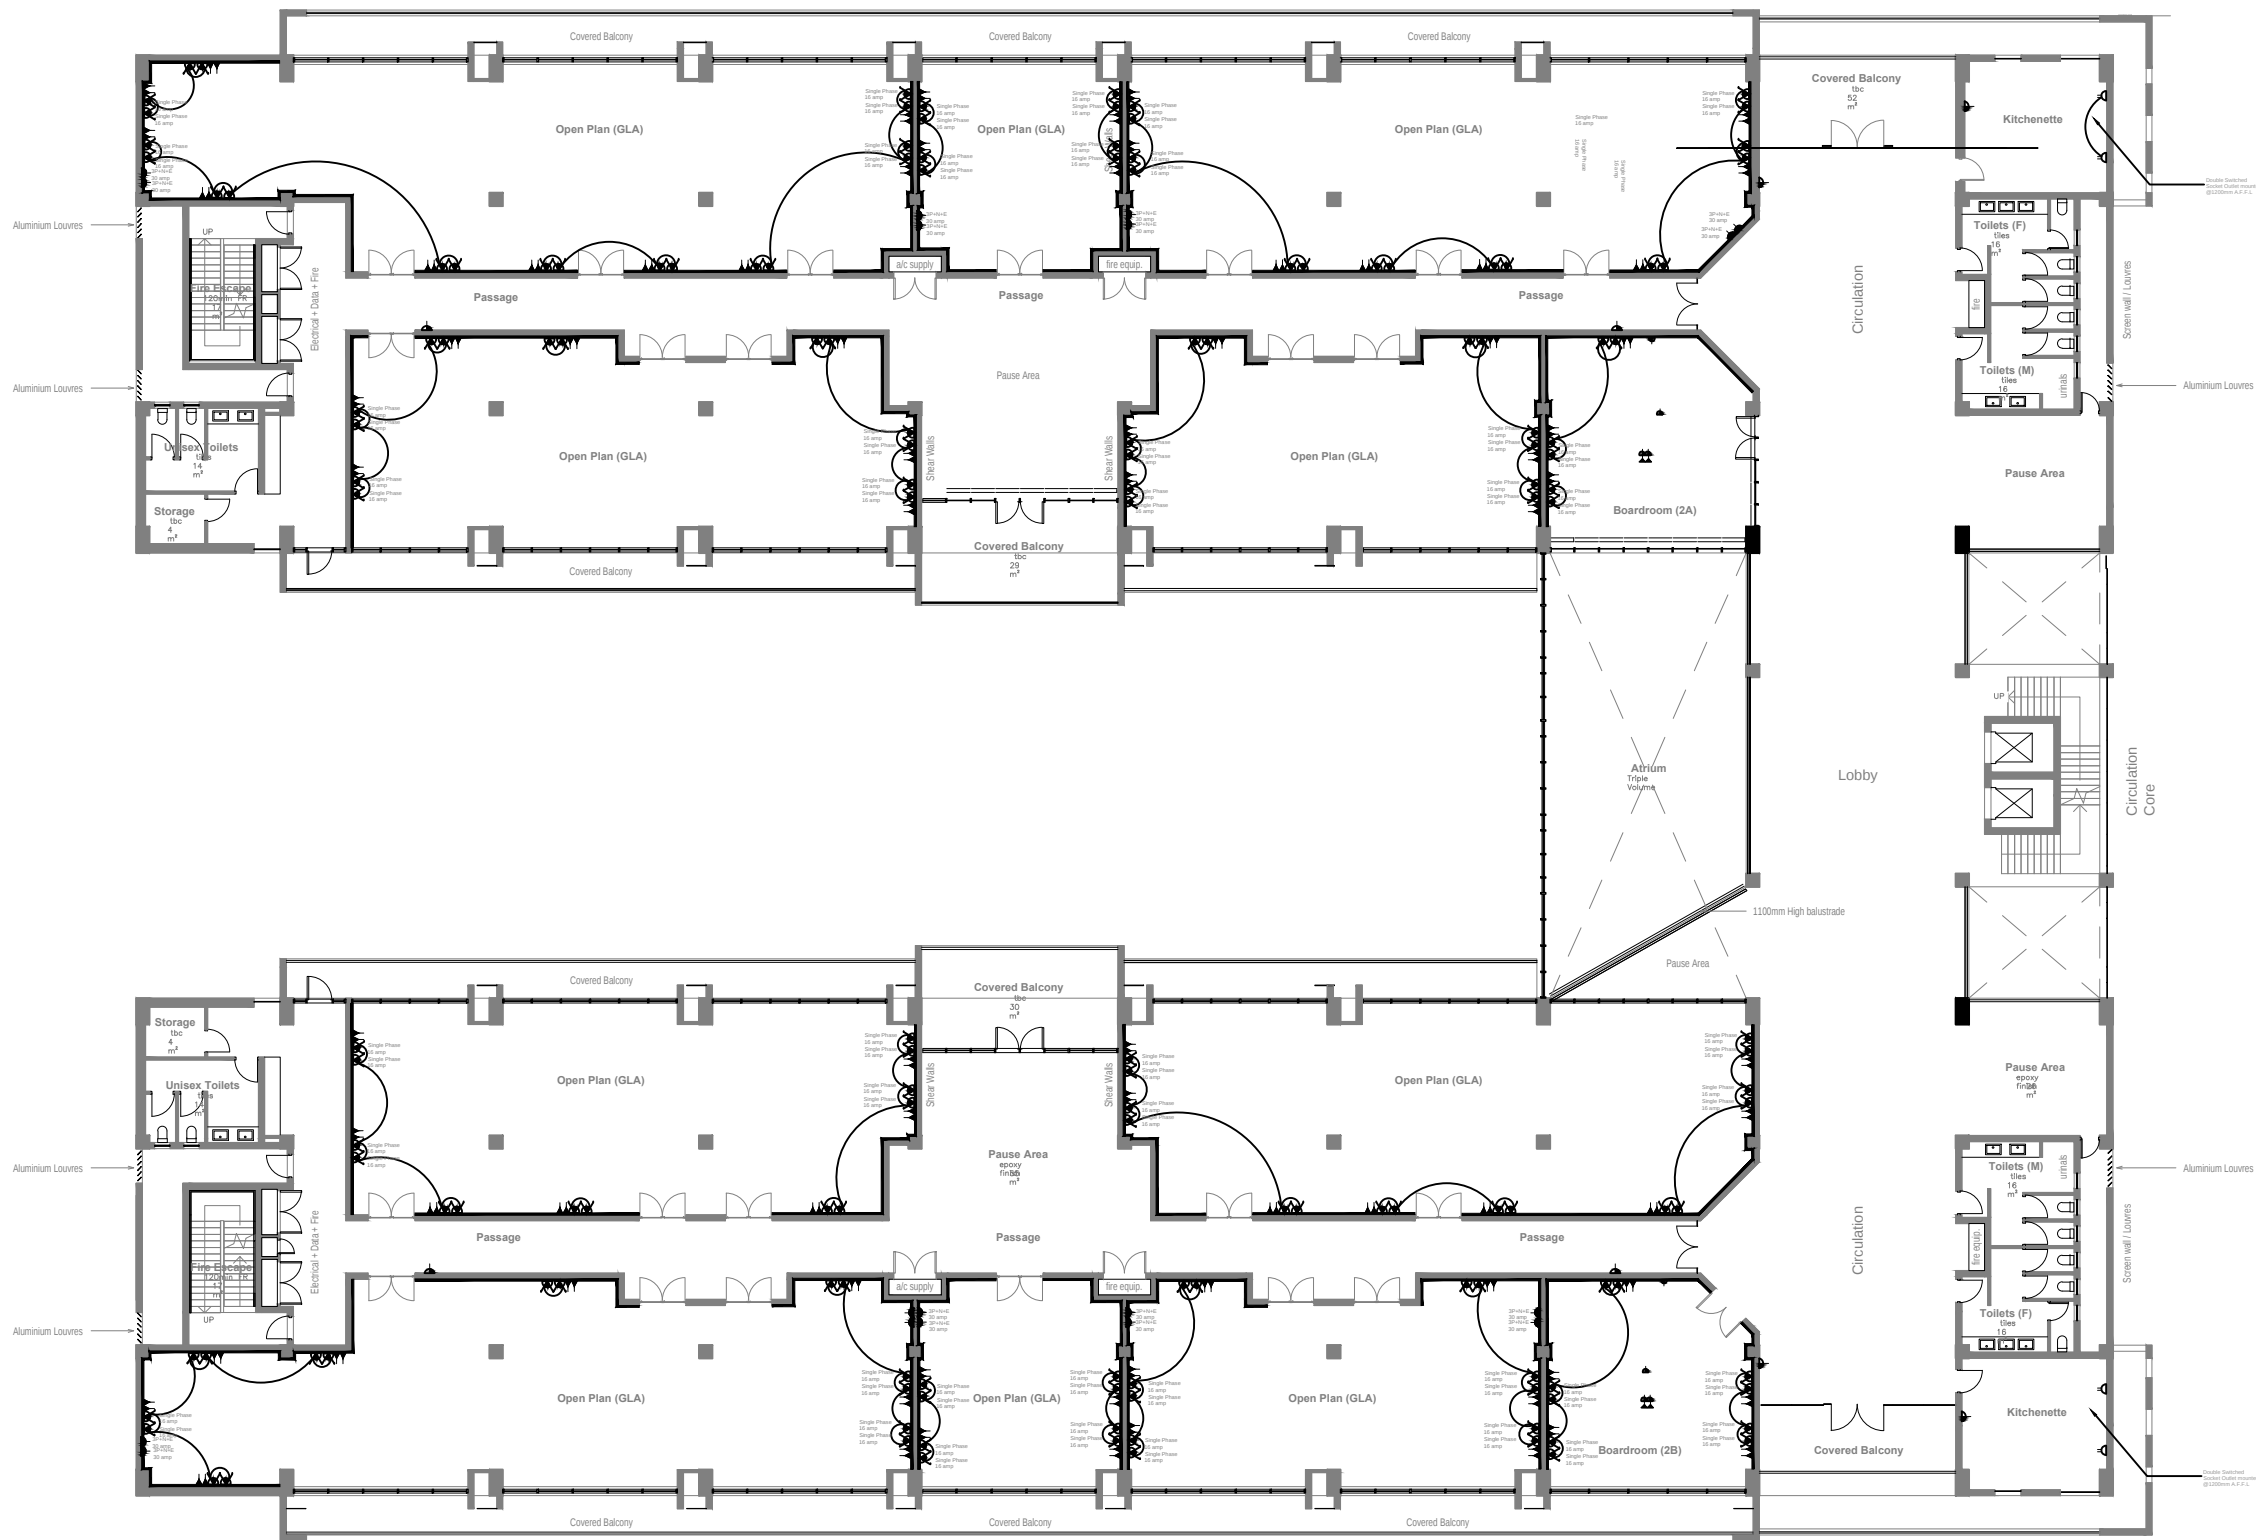

NOTE

1. All flush mounted SSO to be 300mm A.P.F.L unless stated otherwise
2. All surface mounted SSO to be mounted on plaster skirting unless stated otherwise by the engineer
3. All SSO to be wired with 4mm² GP wire
4. The installation must comply with the relevant requirements and SANS

103.42: 1 latest revision
The positions of points might be influenced by built-in furniture or structure on site. The contractor must inform the Eng. on any changes that might occur during construction phase

GENERAL NOTES

- FIGURED DIMENSIONS ONLY TO BE USED.
- COORDINATES BASED ON WGS84
- LEVELS BASED ON MSL DATUM
- DISCREPANCIES, ERRORS AND OMISSIONS ARE TO BE REPORTED TO ENGINEER IMMEDIATELY THEY BECOME EVIDENT.
- SHOP DRAWINGS TO BE SUBMITTED FOR APPROVAL PRIOR TO MANUFACTURE OR INSTALLATION.
- COPYRIGHT AND RIGHT OF REPRODUCTION OF THIS DRAWINGS OR ANY PORTION THEREOF IS RESERVED.

ELECTRICAL LEGEND

	16A 3PIN SINGLE SOCKET OUTLET MOUNTED IN GALVANIZED POWER SKIRTING
	16A 3PIN DOUBLE SOCKET OUTLET FLUSH MOUNTED ON THE WALL AT SPECIFIC HEIGHT
	32A 3PHASE INDUSTRIAL PLUG OUTLET MOUNTED AT SPECIFIC HEIGHT
	16A 3PIN DEDICATED SINGLE SOCKET OUTLET MOUNTED IN GALVANIZED POWER SKIRTING (RED)
	POWER POLE TO BE INSTALLED IN CONCRETE SLAB. FINAL POSITION TO BE DETERMINE ON SITE BY THE ENG.
	INDICATES CIRCUIT No X / DB No X
	INDICATES CIRCUIT No X / DB UPS
	30A FLUSH MOUNTED ISOLATOR FOR AIR CONDITIONING
	DATA OUTLET (RJ45)
	ELECTRICAL DISTRIBUTION BOARD
	POWER SKIRTING RISER INTO CEILING
	TWO COMPARTMENT P9000 POWER SKIRTING

Rev	Date	Issued for	Approved
		Preliminary	
		Information	
00	10/12/2017	Tender Contract	
		Measurement	
		Construction	
		Approval	

Client:

THE INNOVATIONHUB

GAUTENG GROWTH AND DEVELOPMENT AGENCY

Phunga Consulting Engineers
Quality Driven Solutions

Route 21 Corporate Park, Block D, 19 Sovereign Drive Irene,
Centurion, 0157 South Africa,
Tel: (+27)12 345 6694, Fax: (+27)12 345 6813,
E-mail: info@phunga.co.za,
Web: www.phunga.co.za

Project Title:
Innovation Hub
Electrical Services

Drawing Title: Second Floor Lighting Design PHG-SFLD-01	Designed by: G. Mabika
Date: Dec 2017	Drawn by: G. Mabika
Scale: 1:100	Checked by: MJ Ezyeka, Pr No 200930078

