


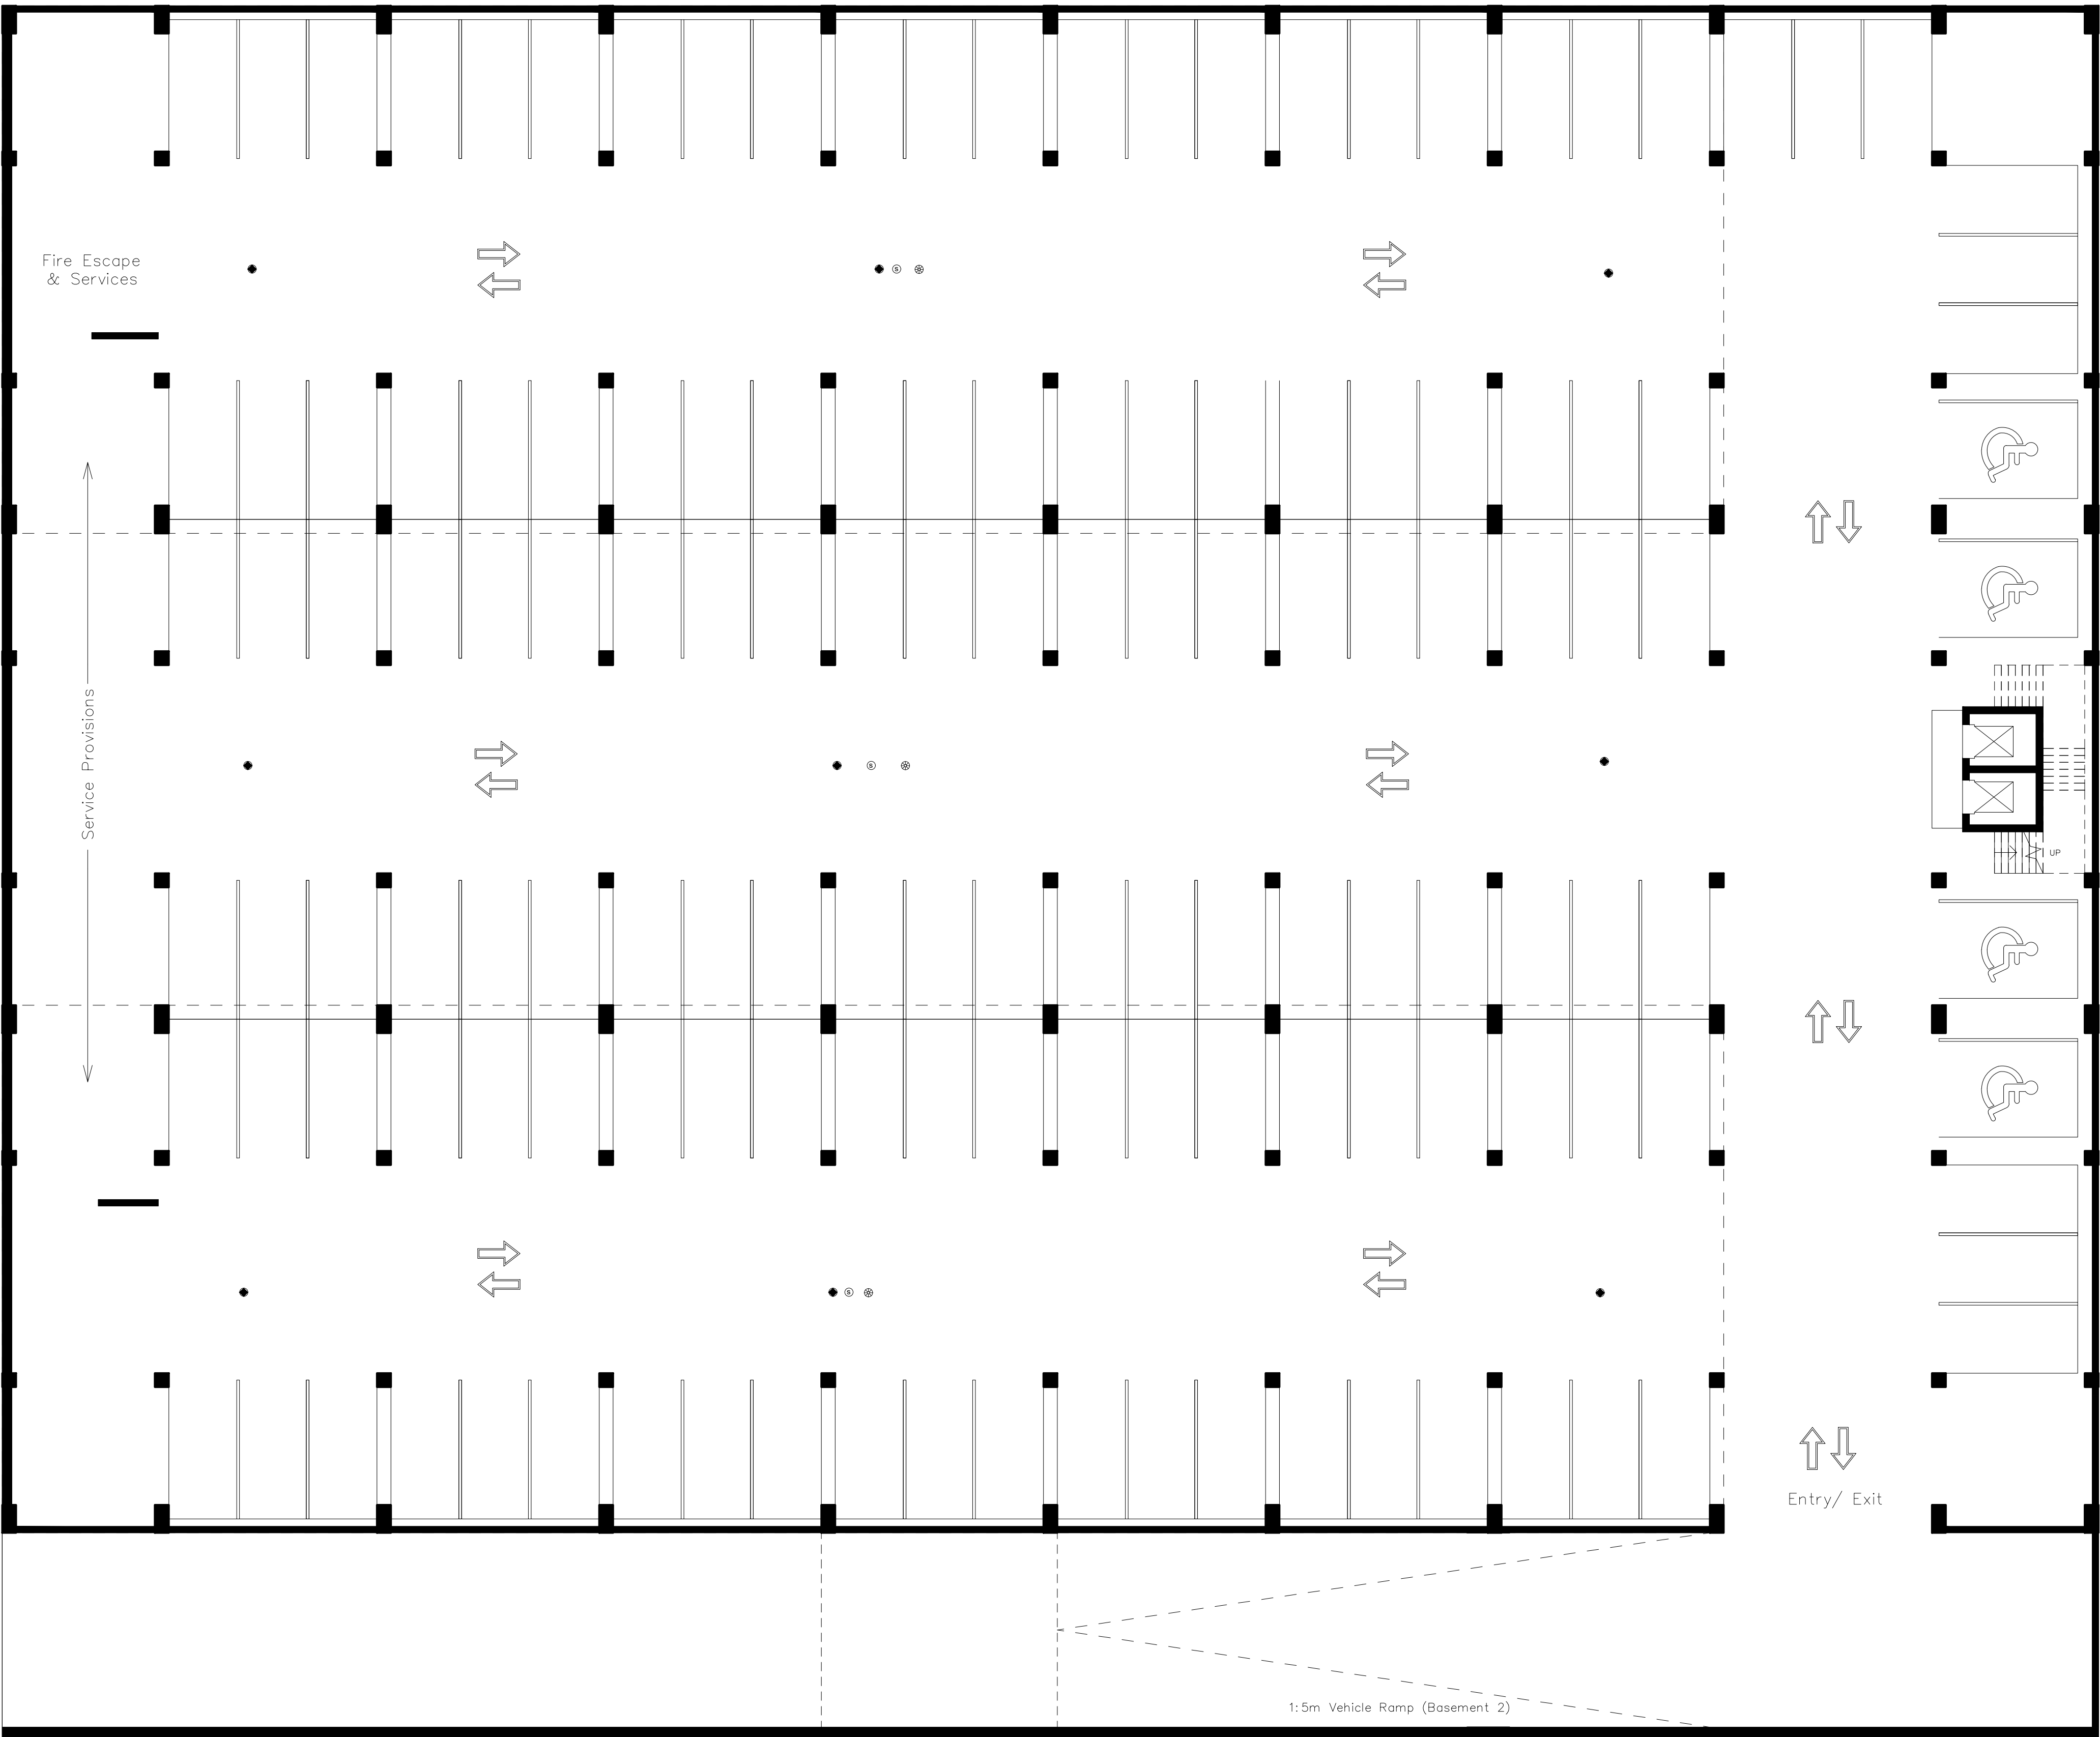

LEGEND:	
	SMOKE DETECTOR ON CEILING
	STROBE BEACON LIGHT
	STANDARD SPEAKER
	DETECTION DISTRIBUTION PANEL

- GENERAL NOTES**
- FIGURED DIMENSIONS ONLY TO BE USED.
 - COORDINATES BASED ON WGS84
 - LEVELS BASED ON MSL DATUM
 - DISCREPANCIES, ERRORS AND OMISSIONS ARE TO BE REPORTED TO ENGINEER IMMEDIATELY THEY BECOME EVIDENT.
 - SHOP DRAWINGS TO BE SUBMITTED FOR APPROVAL PRIOR TO MANUFACTURE OR INSTALLATION.
 - COPYRIGHT AND RIGHT OF REPRODUCTION OF THIS DRAWINGS OR ANY PORTION THEREOF IS RESERVED.

Rev	Date	Issued for	Approved
0	15/11/17	Preliminary	
		Information	
		Tender Contract	
		Measurement	
		Construction	
		Approval	

Client:

THE INNOVATIONHUB

BAUTENG GROWTH AND DEVELOPMENT AGENCY

Phunga Consulting Engineers
Quality driven solutions

Route 21 Corporate Park, Block D, 19 Sovereign Drive Irene,
Centurion, 0157 South Africa,
Tel: (+27)12 345 6694, Fax: (+27)12 345 6813,
E-mail: info@phunga.co.za,
Web: www.phunga.co.za

Project Title:
New Biotechnology Industrial Park Phase 3

Drawing Title: PHG-BS2 F-204-Fire Detection 01 Rev_0	Designed by: L.G; Eng
Date November 2017	Drawn by: L.G; Eng
Scale As shown	Checked by: L.G; Eng

BASEMENT 2 FLOOR PLAN
Scale 1:100

