


BASEMENT 1 FLOOR PLAN
Scale 1:100

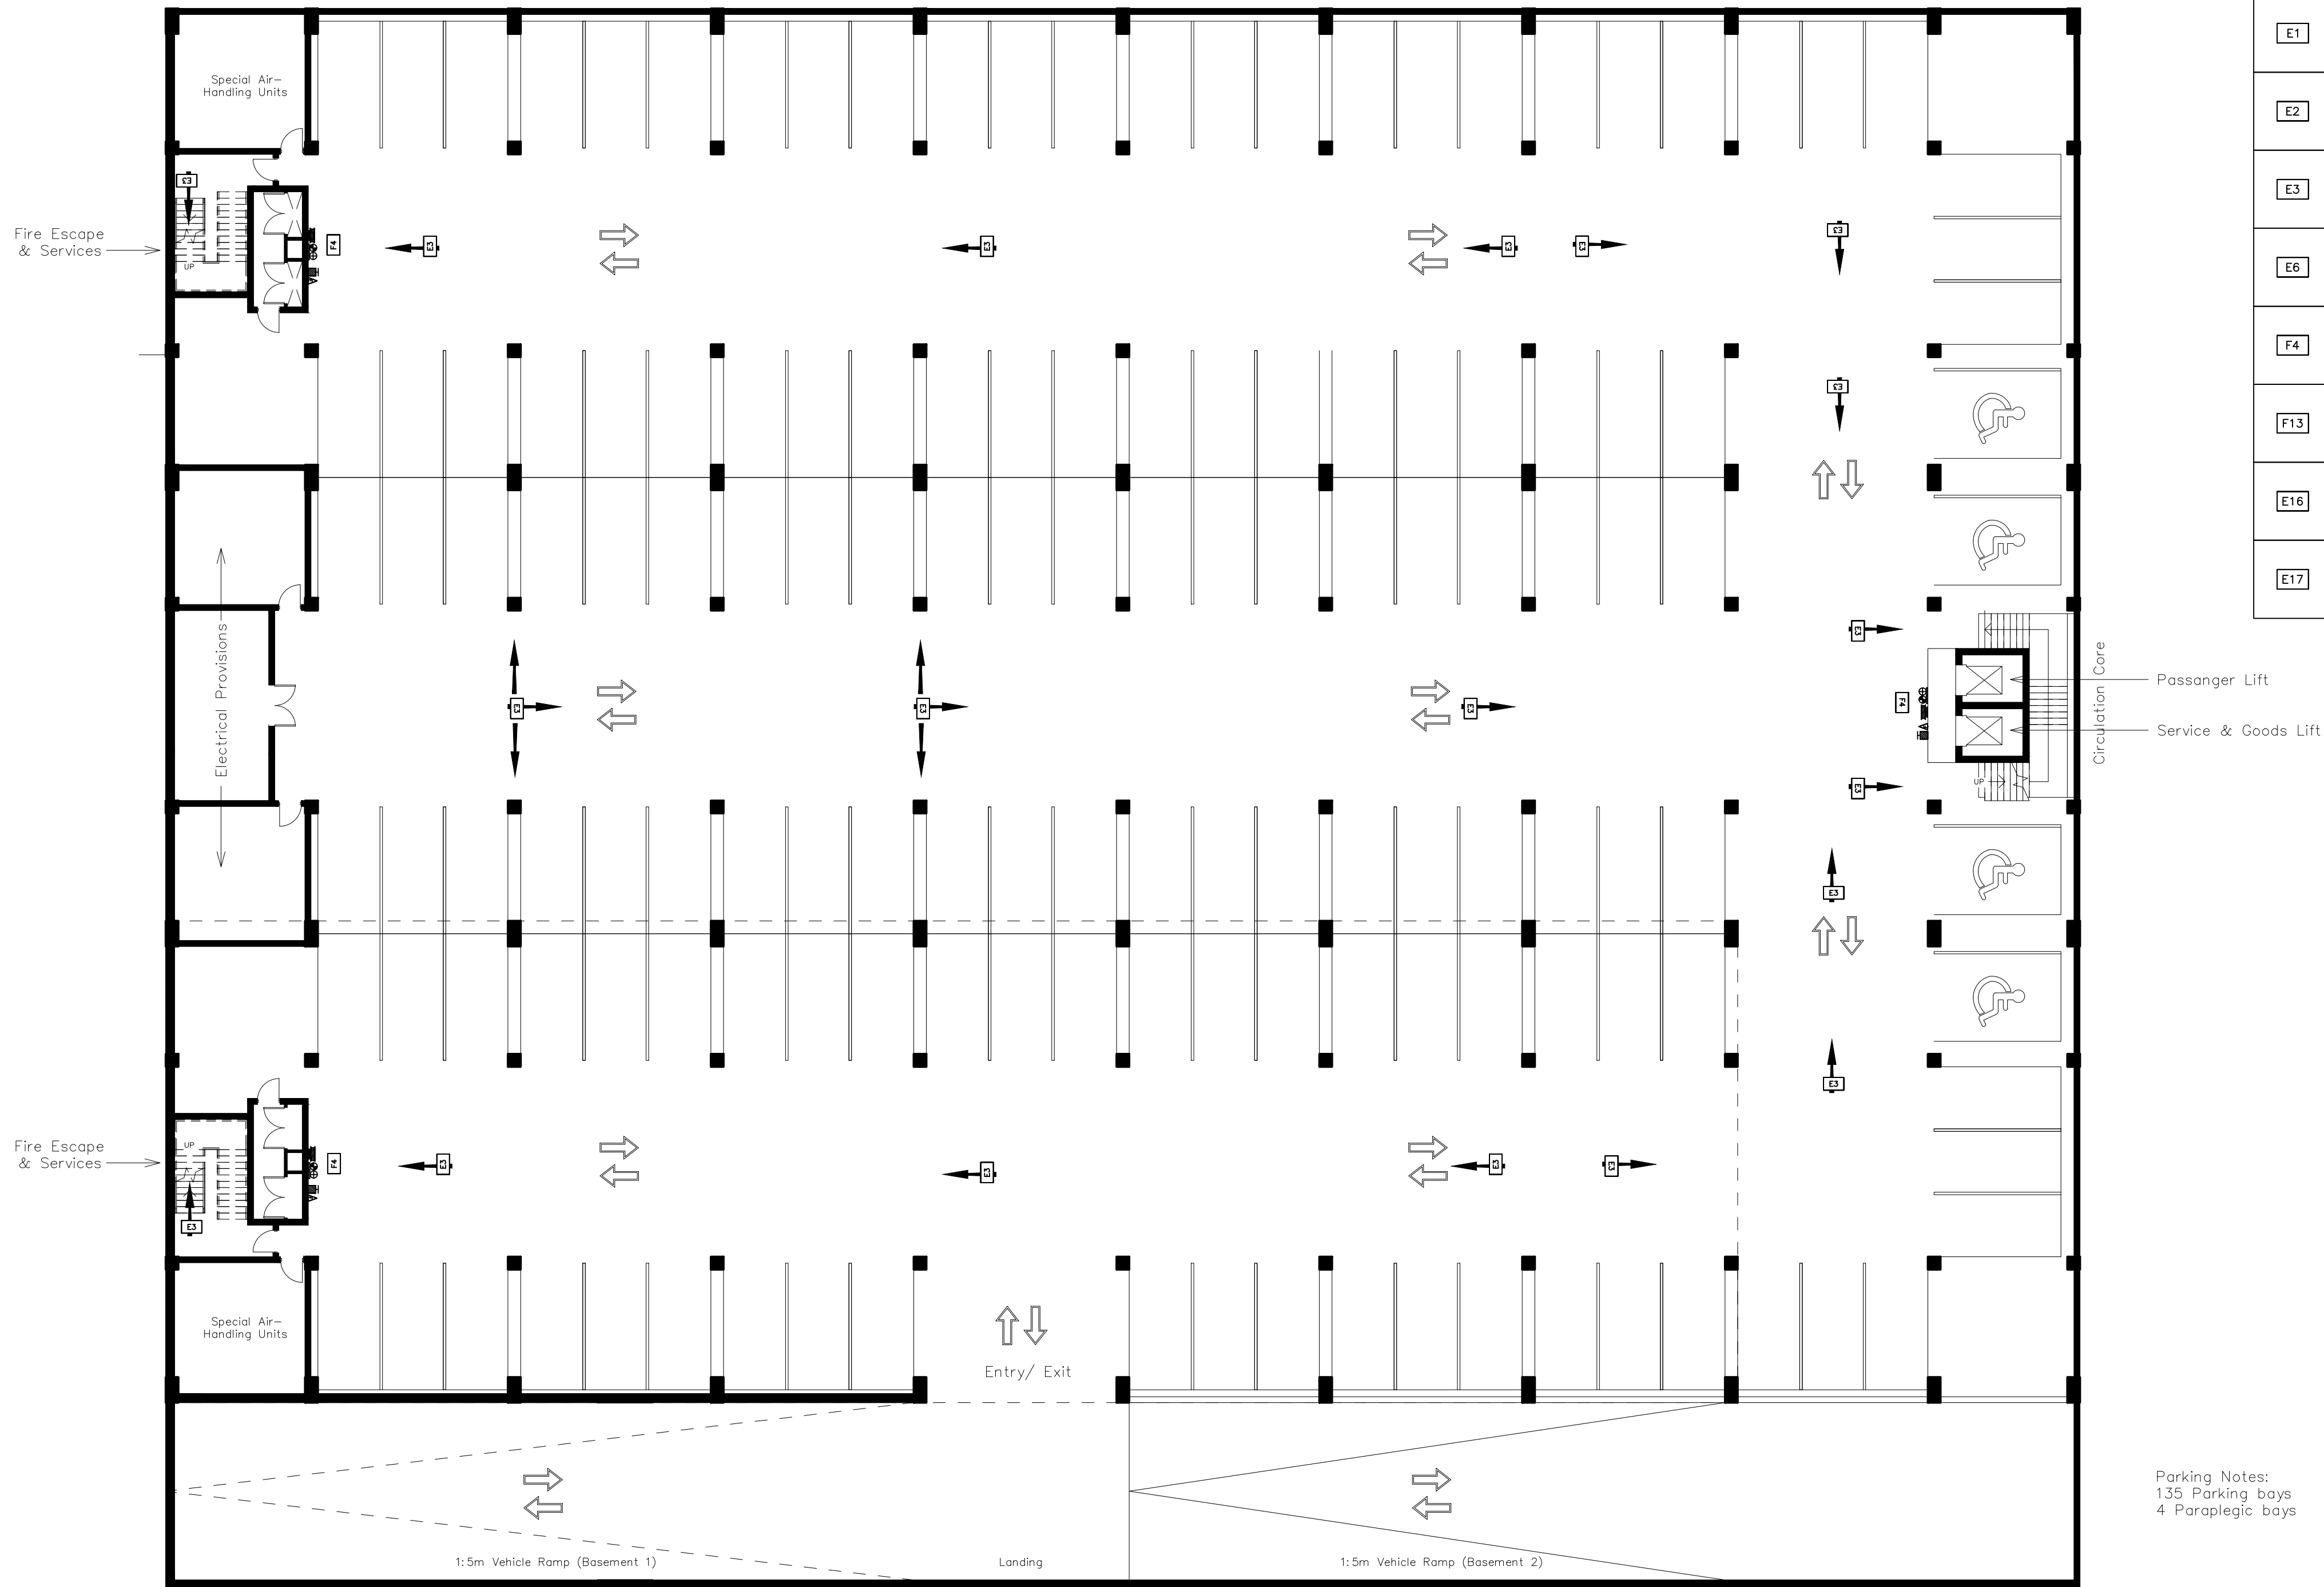

Parking Notes:
135 Parking bays
4 Paraplegic bays

FIRE LEGEND		
Symbol	QTY	Description
	·	FIRE EXTINGUISHER 4.5kg (DCP).
	·	FIRE EXTINGUISHER 5kg (CO ₂).
	·	FIRE HOSE REEL.
	·	ø65 HYDRANT
SIGNAGE REFERENCE	SIGNAGE PREVIEW	QUANTITY
E1		
E2		
E3		
E6		
F4		
F13		
E16		
E17		

GENERAL NOTES

- FIGURED DIMENSIONS ONLY TO BE USED.
- COORDINATES BASED ON WGS84
- LEVELS BASED ON MSL DATUM
- DISCREPANCIES, ERRORS AND OMISSIONS ARE TO BE REPORTED TO ENGINEER IMMEDIATELY THEY BECOME EVIDENT.
- SHOP DRAWINGS TO BE SUBMITTED FOR APPROVAL PRIOR TO MANUFACTURE OR INSTALLATION.
- COPYRIGHT AND RIGHT OF REPRODUCTION OF THIS DRAWINGS OR ANY PORTION THEREOF IS RESERVED.

Rev	Date	Issued for	Approved
0	15/11/17	Preliminary	
		Information	
		Tender Contract	
		Measurement	
		Construction	
		Approval	

Client:

THE INNOVATIONHUB

GAUTENG GROWTH AND DEVELOPMENT AGENCY

Phunga Consulting Engineers
Quality Driven Solutions

Route 21 Corporate Park, Block D, 19 Sovereign Drive Irene,
Centurion, 0157 South Africa,
Tel: (+27)12 345 6694, Fax: (+27)12 345 6813,
E-mail: info@phunga.co.za,
Web: www.phunga.co.za

Project Title:
New Biotechnology Industrial Park Phase 3

Drawing Title: PHG-BS1 F-205-Fire Protection 01 Rev_0	Designed by: L.G; Eng
Date November 2017	Drawn by: L.G; Eng
Scale As shown	Checked by: L.G; Eng

