


FIRST FLOOR PLAN  
Scale 1:100

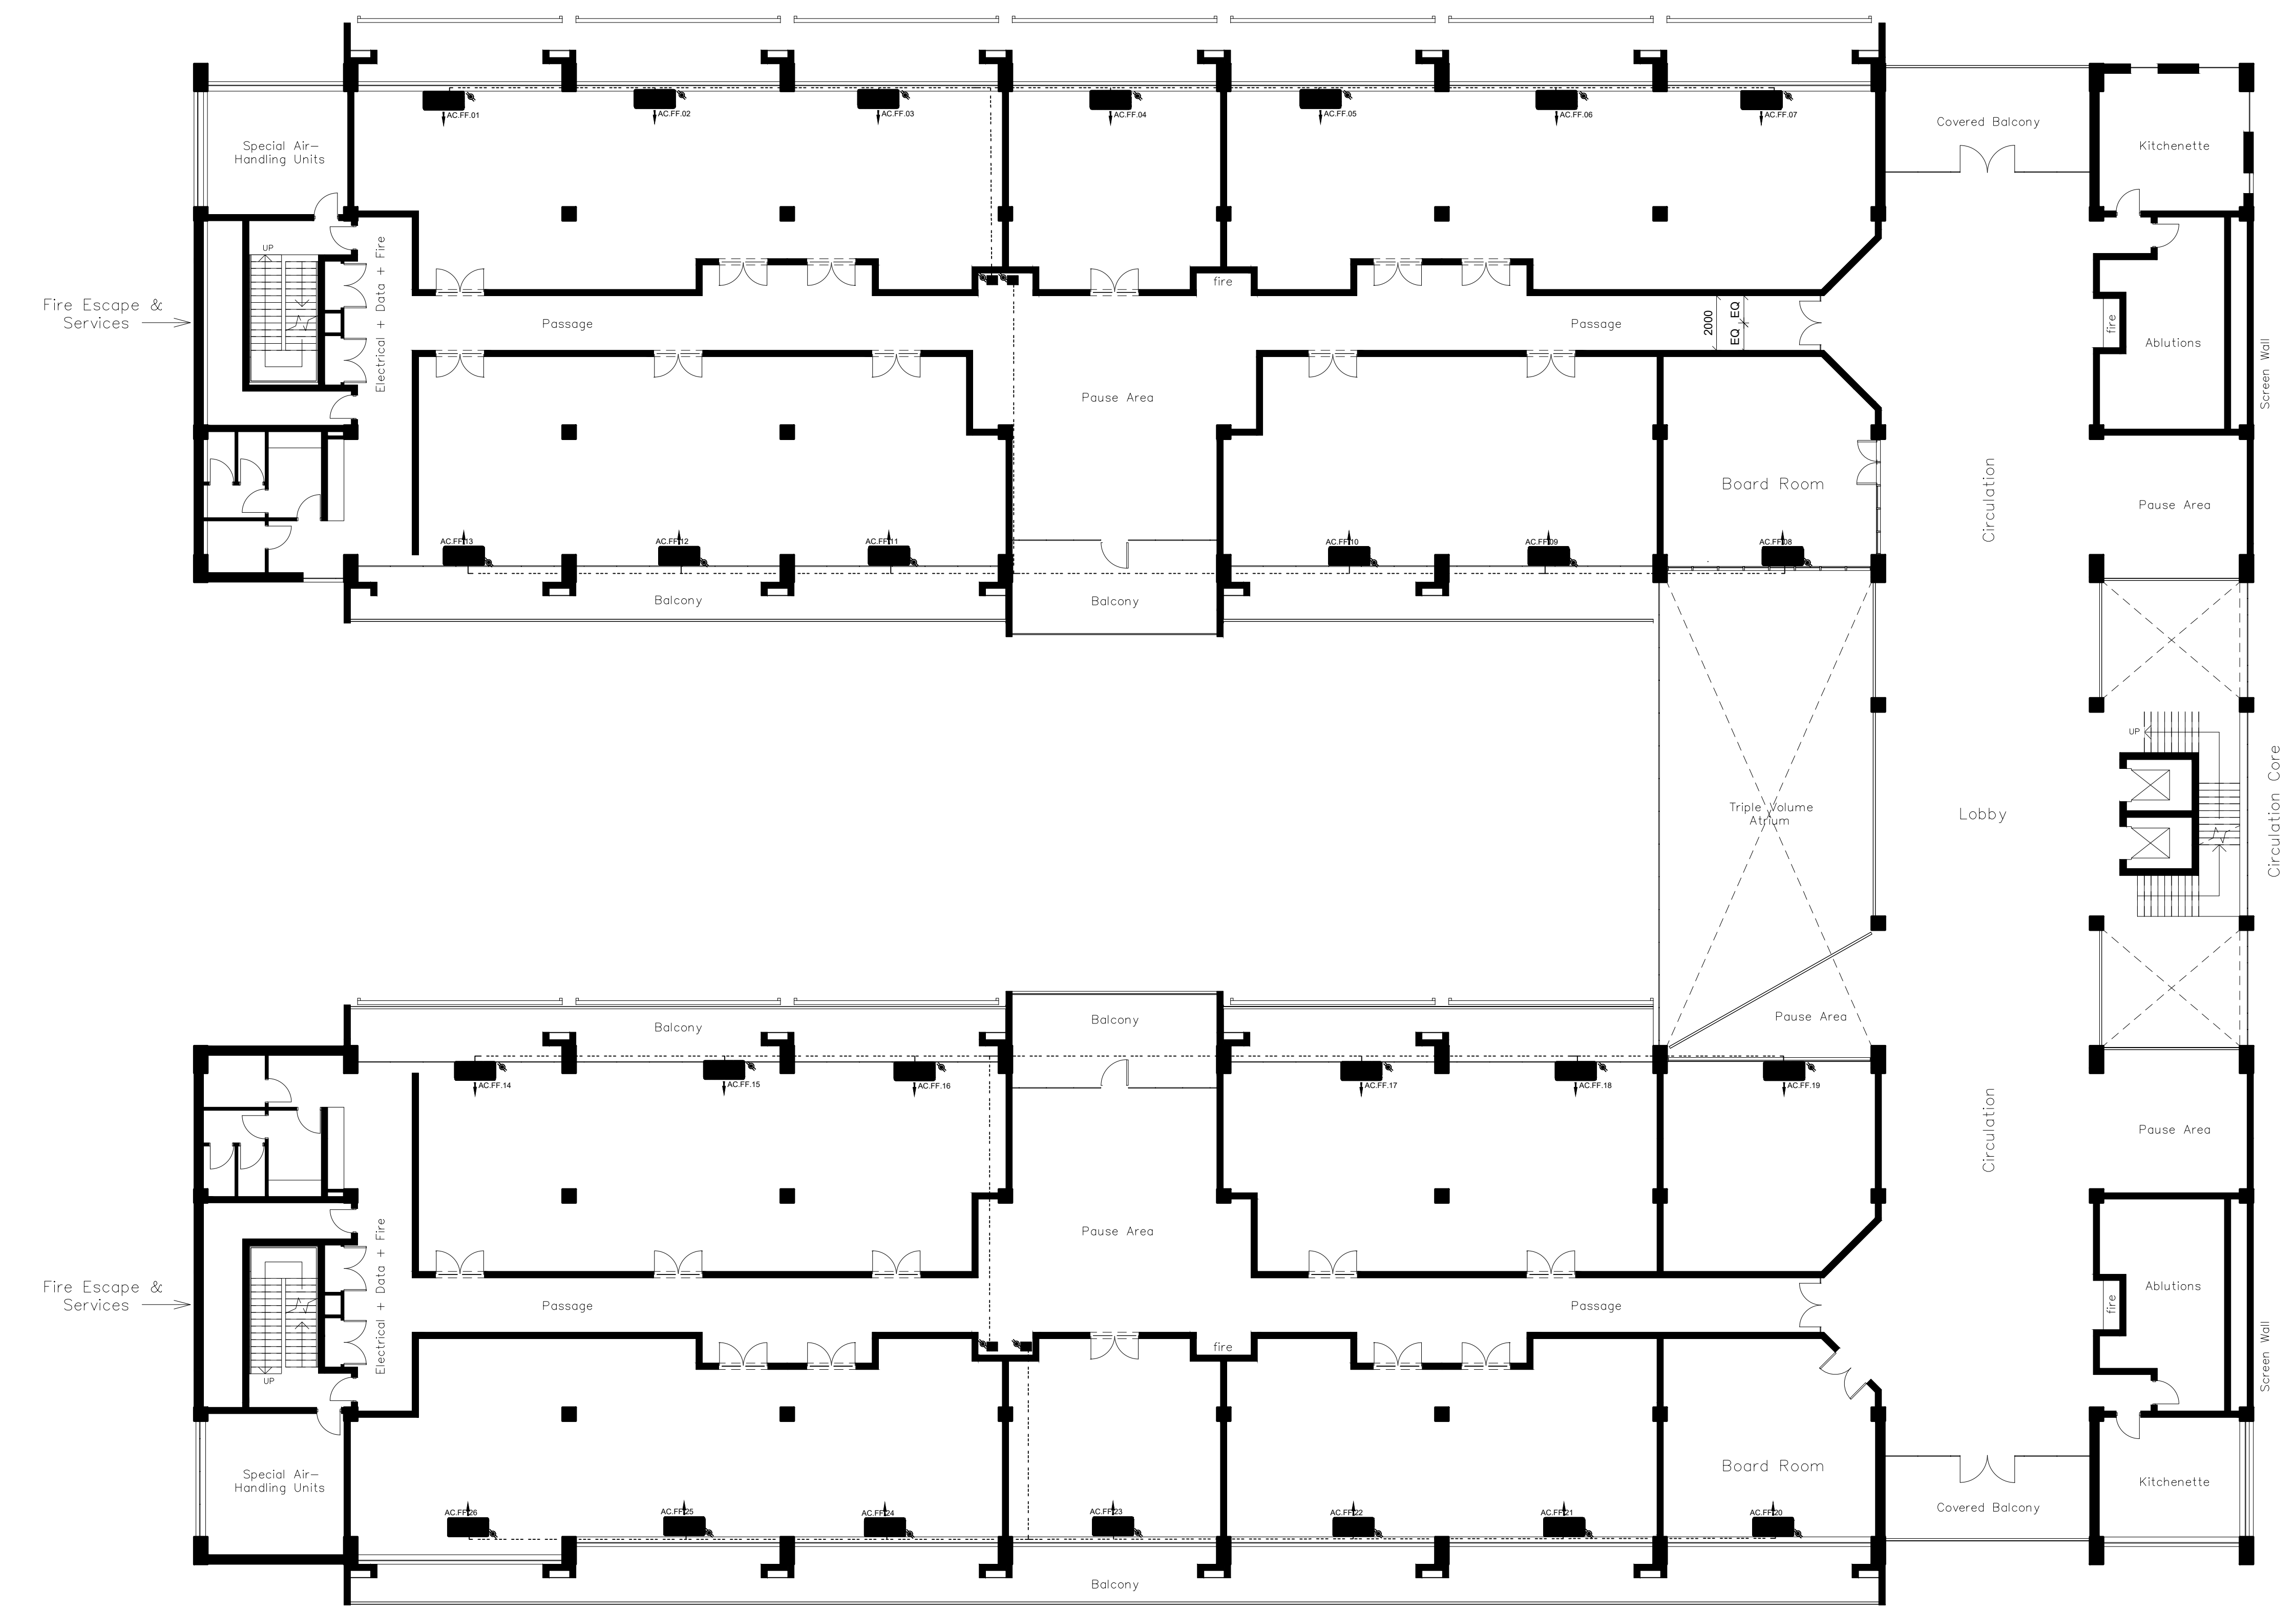

| LEGEND: |                              |
|---------|------------------------------|
|         | - EXTRACT AIR DUCTING        |
|         | - SINGLE PHASE ISOLATOR      |
|         | - THREE PHASE ISOLATOR       |
|         | - AC CONTROLLER WITH DRAWBOX |
|         | - PRIMARY REFRIGERANT PIPING |
|         | - MAIN CONDENSATE LINE       |
|         | - UNDER CEILING UNIT         |
|         | - BS BOX                     |
|         | - OUTDOOR UNIT               |

- GENERAL NOTES**
- FIGURED DIMENSIONS ONLY TO BE USED.
  - COORDINATES BASED ON WGS84
  - LEVELS BASED ON MSL DATUM
  - DISCREPANCIES, ERRORS AND OMISSIONS ARE TO BE REPORTED TO ENGINEER IMMEDIATELY THEY BECOME EVIDENT.
  - SHOP DRAWINGS TO BE SUBMITTED FOR APPROVAL PRIOR TO MANUFACTURE OR INSTALLATION.
  - COPYRIGHT AND RIGHT OF REPRODUCTION OF THIS DRAWINGS OR ANY PORTION THEREOF IS RESERVED.

| Rev | Date     | Issued for      | Approved |
|-----|----------|-----------------|----------|
| 0   | 25/07/17 | Preliminary     |          |
|     |          | Information     |          |
|     |          | Tender Contract |          |
|     |          | Measurement     |          |
|     |          | Construction    |          |
|     |          | Approval        |          |

Client:

**THE INNOVATIONHUB**

GAUTENG GROWTH AND DEVELOPMENT AGENCY

**Phunga Consulting Engineers**  
Quality Growth Solutions

Route 21 Corporate Park, Block D, 19 Sovereign Drive Irene,  
Centurion, 0157 South Africa,  
Tel: (+27)12 345 6694, Fax: (+27)12 345 6813,  
E-mail: [info@phunga.co.za](mailto:info@phunga.co.za),  
Web: [www.phunga.co.za](http://www.phunga.co.za)

**Project Title:**  
New Biotechnology Industrial Park Phase 3

|                                                    |                                 |
|----------------------------------------------------|---------------------------------|
| <b>Drawing Title:</b><br>PHG-FE-202-HV 01<br>Rev_0 | <b>Designed by:</b><br>L.G; Eng |
| <b>Date</b><br>November 2017                       | <b>Drawn by:</b><br>L.G; Eng    |
| <b>Scale</b><br>As shown                           | <b>Checked by:</b><br>L.G; Eng  |

