


GENERAL NOTES

- FIGURED DIMENSIONS ONLY TO BE USED.
- COORDINATES BASED ON WGS84
- LEVELS BASED ON MSL DATUM
- DISCREPANCIES, ERRORS AND OMISSIONS ARE TO BE REPORTED TO ENGINEER IMMEDIATELY THEY BECOME EVIDENT.
- SHOP DRAWINGS TO BE SUBMITTED FOR APPROVAL PRIOR TO MANUFACTURE OR INSTALLATION.
- COPYRIGHT AND RIGHT OF REPRODUCTION OF THIS DRAWINGS OR ANY PORTION THEREOF IS RESERVED.

LEGEND:

	- EXTRACT AIR DUCTING
	- SINGLE PHASE ISOLATOR
	- THREE PHASE ISOLATOR
	- AC CONTROLLER WITH DRAWBOX
	- PRIMARY REFRIGERANT PIPING
	- MAIN CONDENSATE LINE
	- UNDER CEILING UNIT
	- BS BOX
	- OUTDOOR UNIT

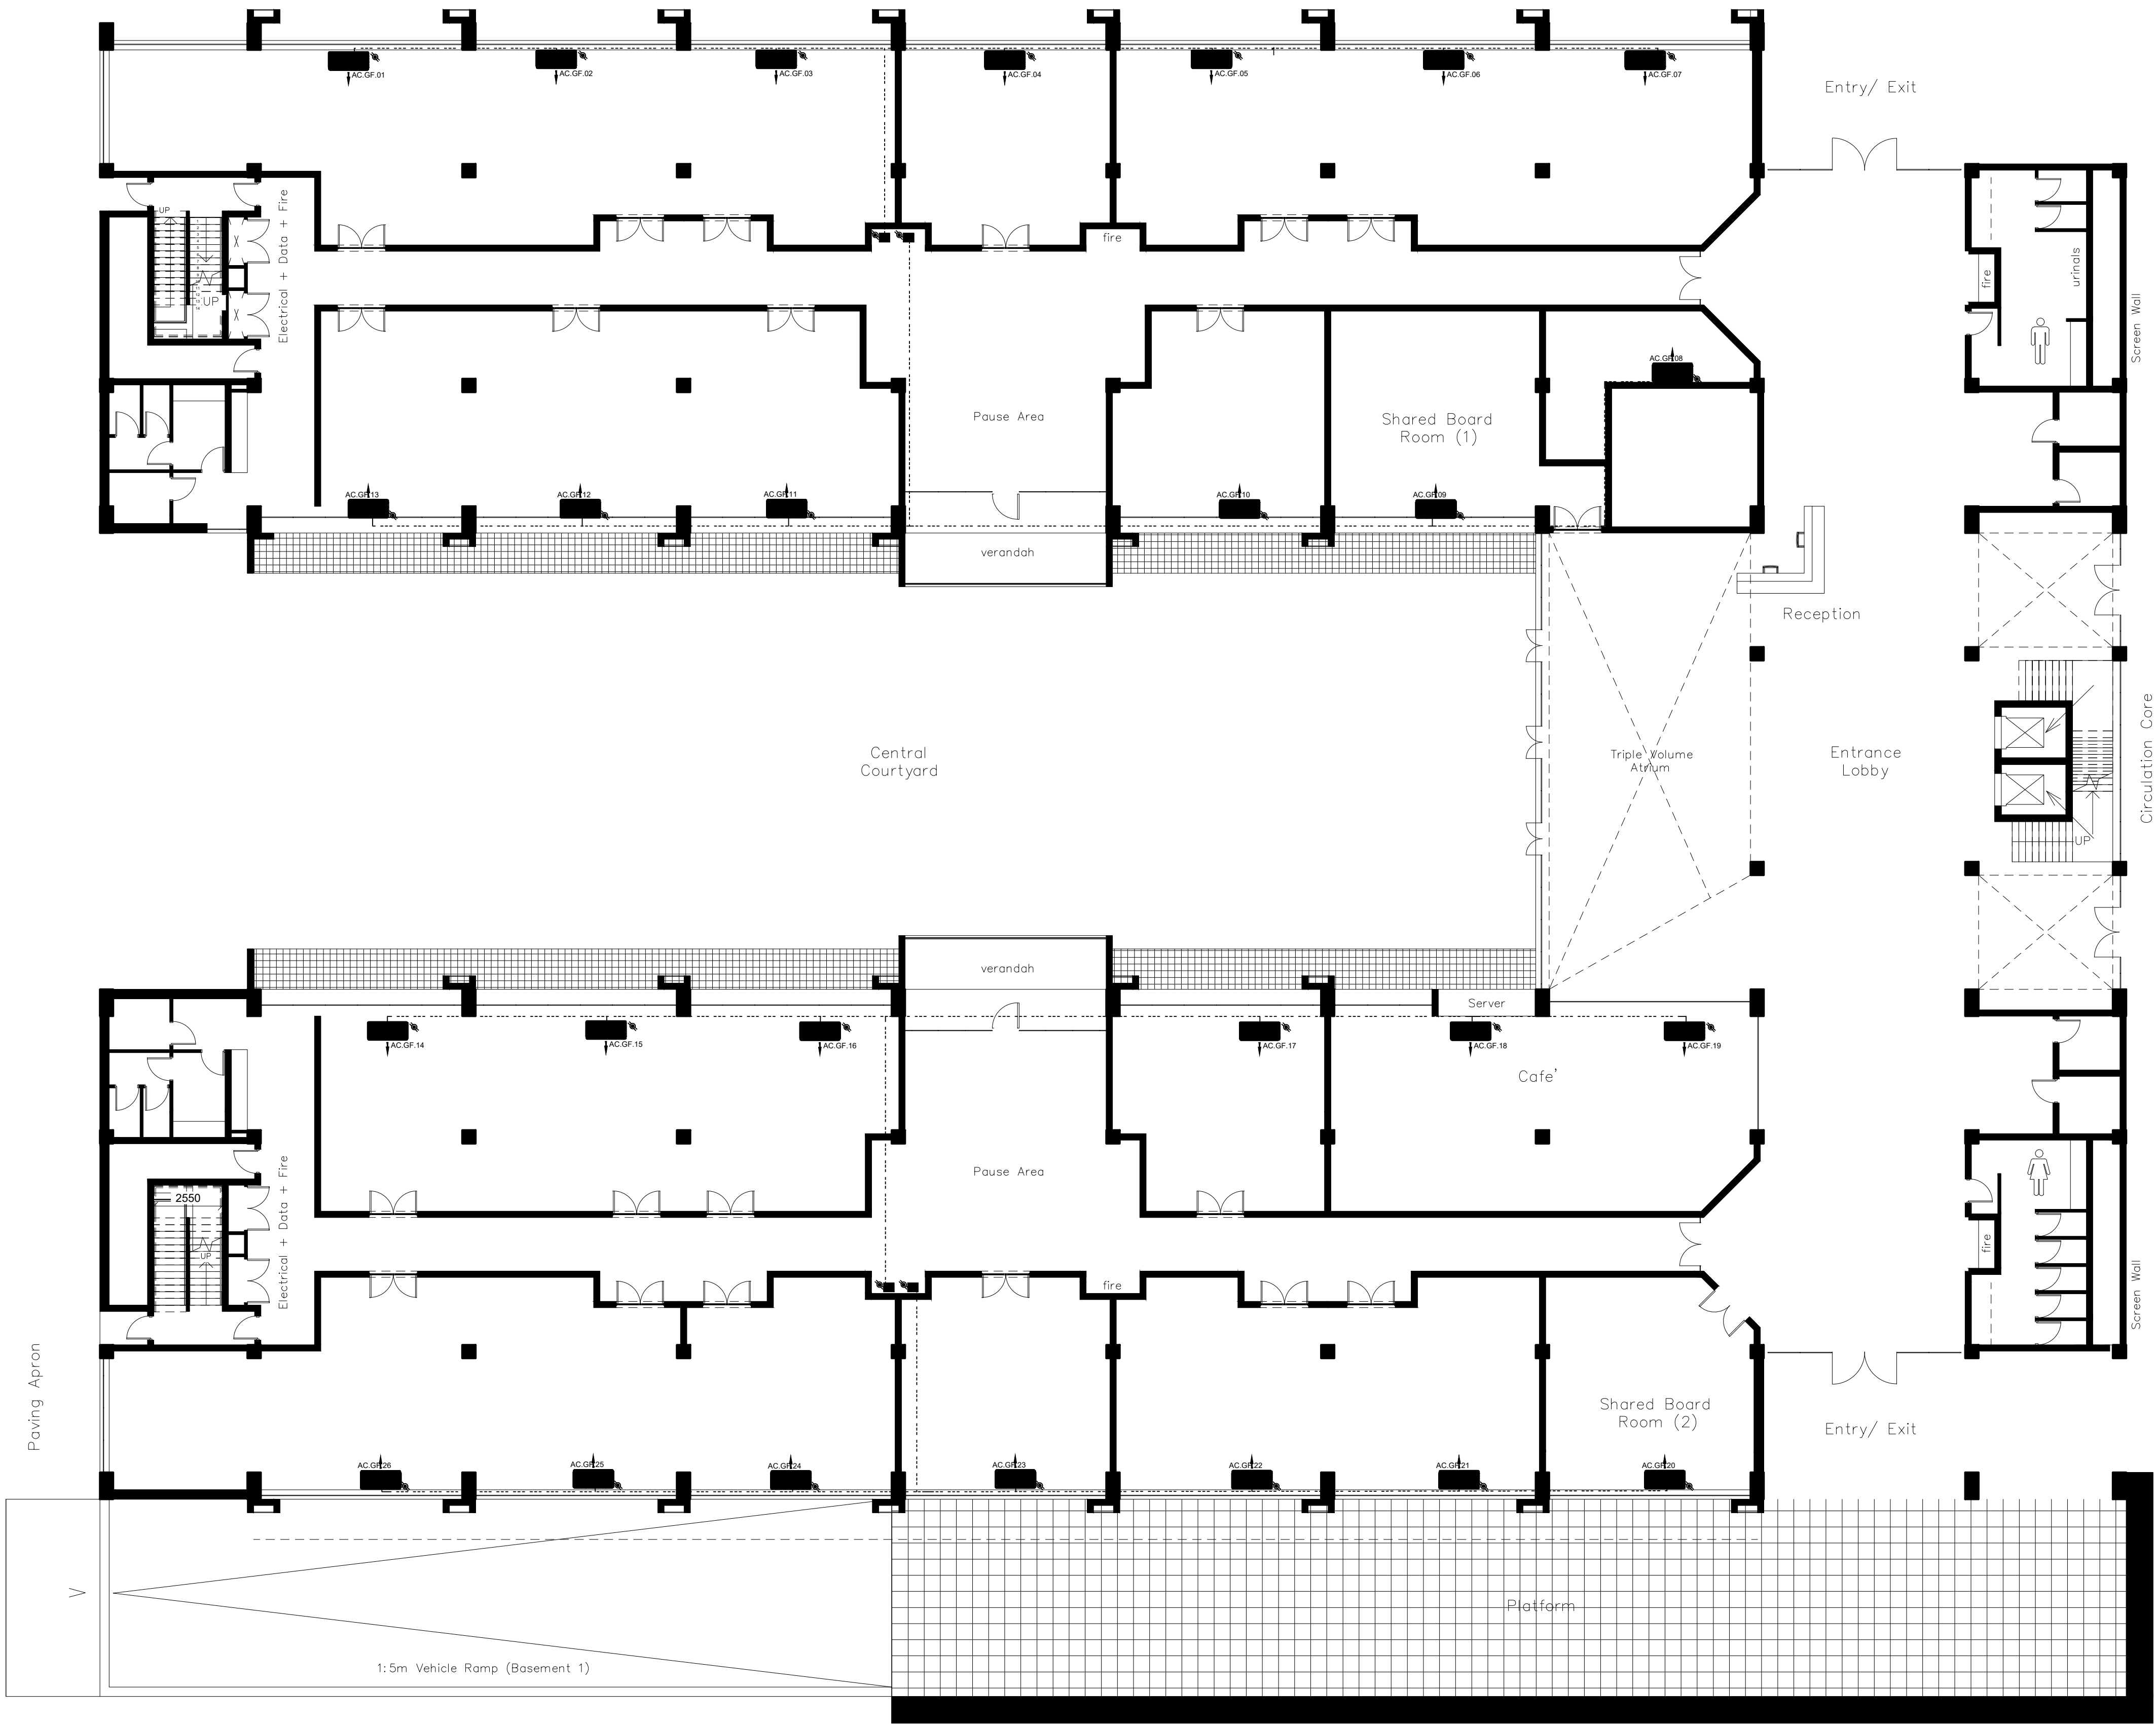

GROUND FLOOR PLAN
Scale 1:100

Rev	Date	Issued for	Approved
0	15/11/17	Preliminary	
		Information	
		Tender Contract	
		Measurement	
		Construction	
		Approval	

Client:

THE INNOVATION HUB

GAUTENG GROWTH AND DEVELOPMENT AGENCY

Phunga Consulting Engineers
QUALITY DESIGN SOLUTIONS

Route 21 Corporate Park, Block D, 19 Sovereign Drive Irene,
Centurion, 0157 South Africa,
Tel: (+27)12 345 6694, Fax: (+27)12 345 6813,
E-mail: info@phunga.co.za,
Web: www.phunga.co.za

Project Title:
New Biotechnology Industrial Park Phase 3

Drawing Title: PHG-GF-201-HV 01 Rev_0	Designed by: L.G; Eng
Date: November 2017	Drawn by: L.G; Eng
Scale: As shown	Checked by: L.G; Eng

